









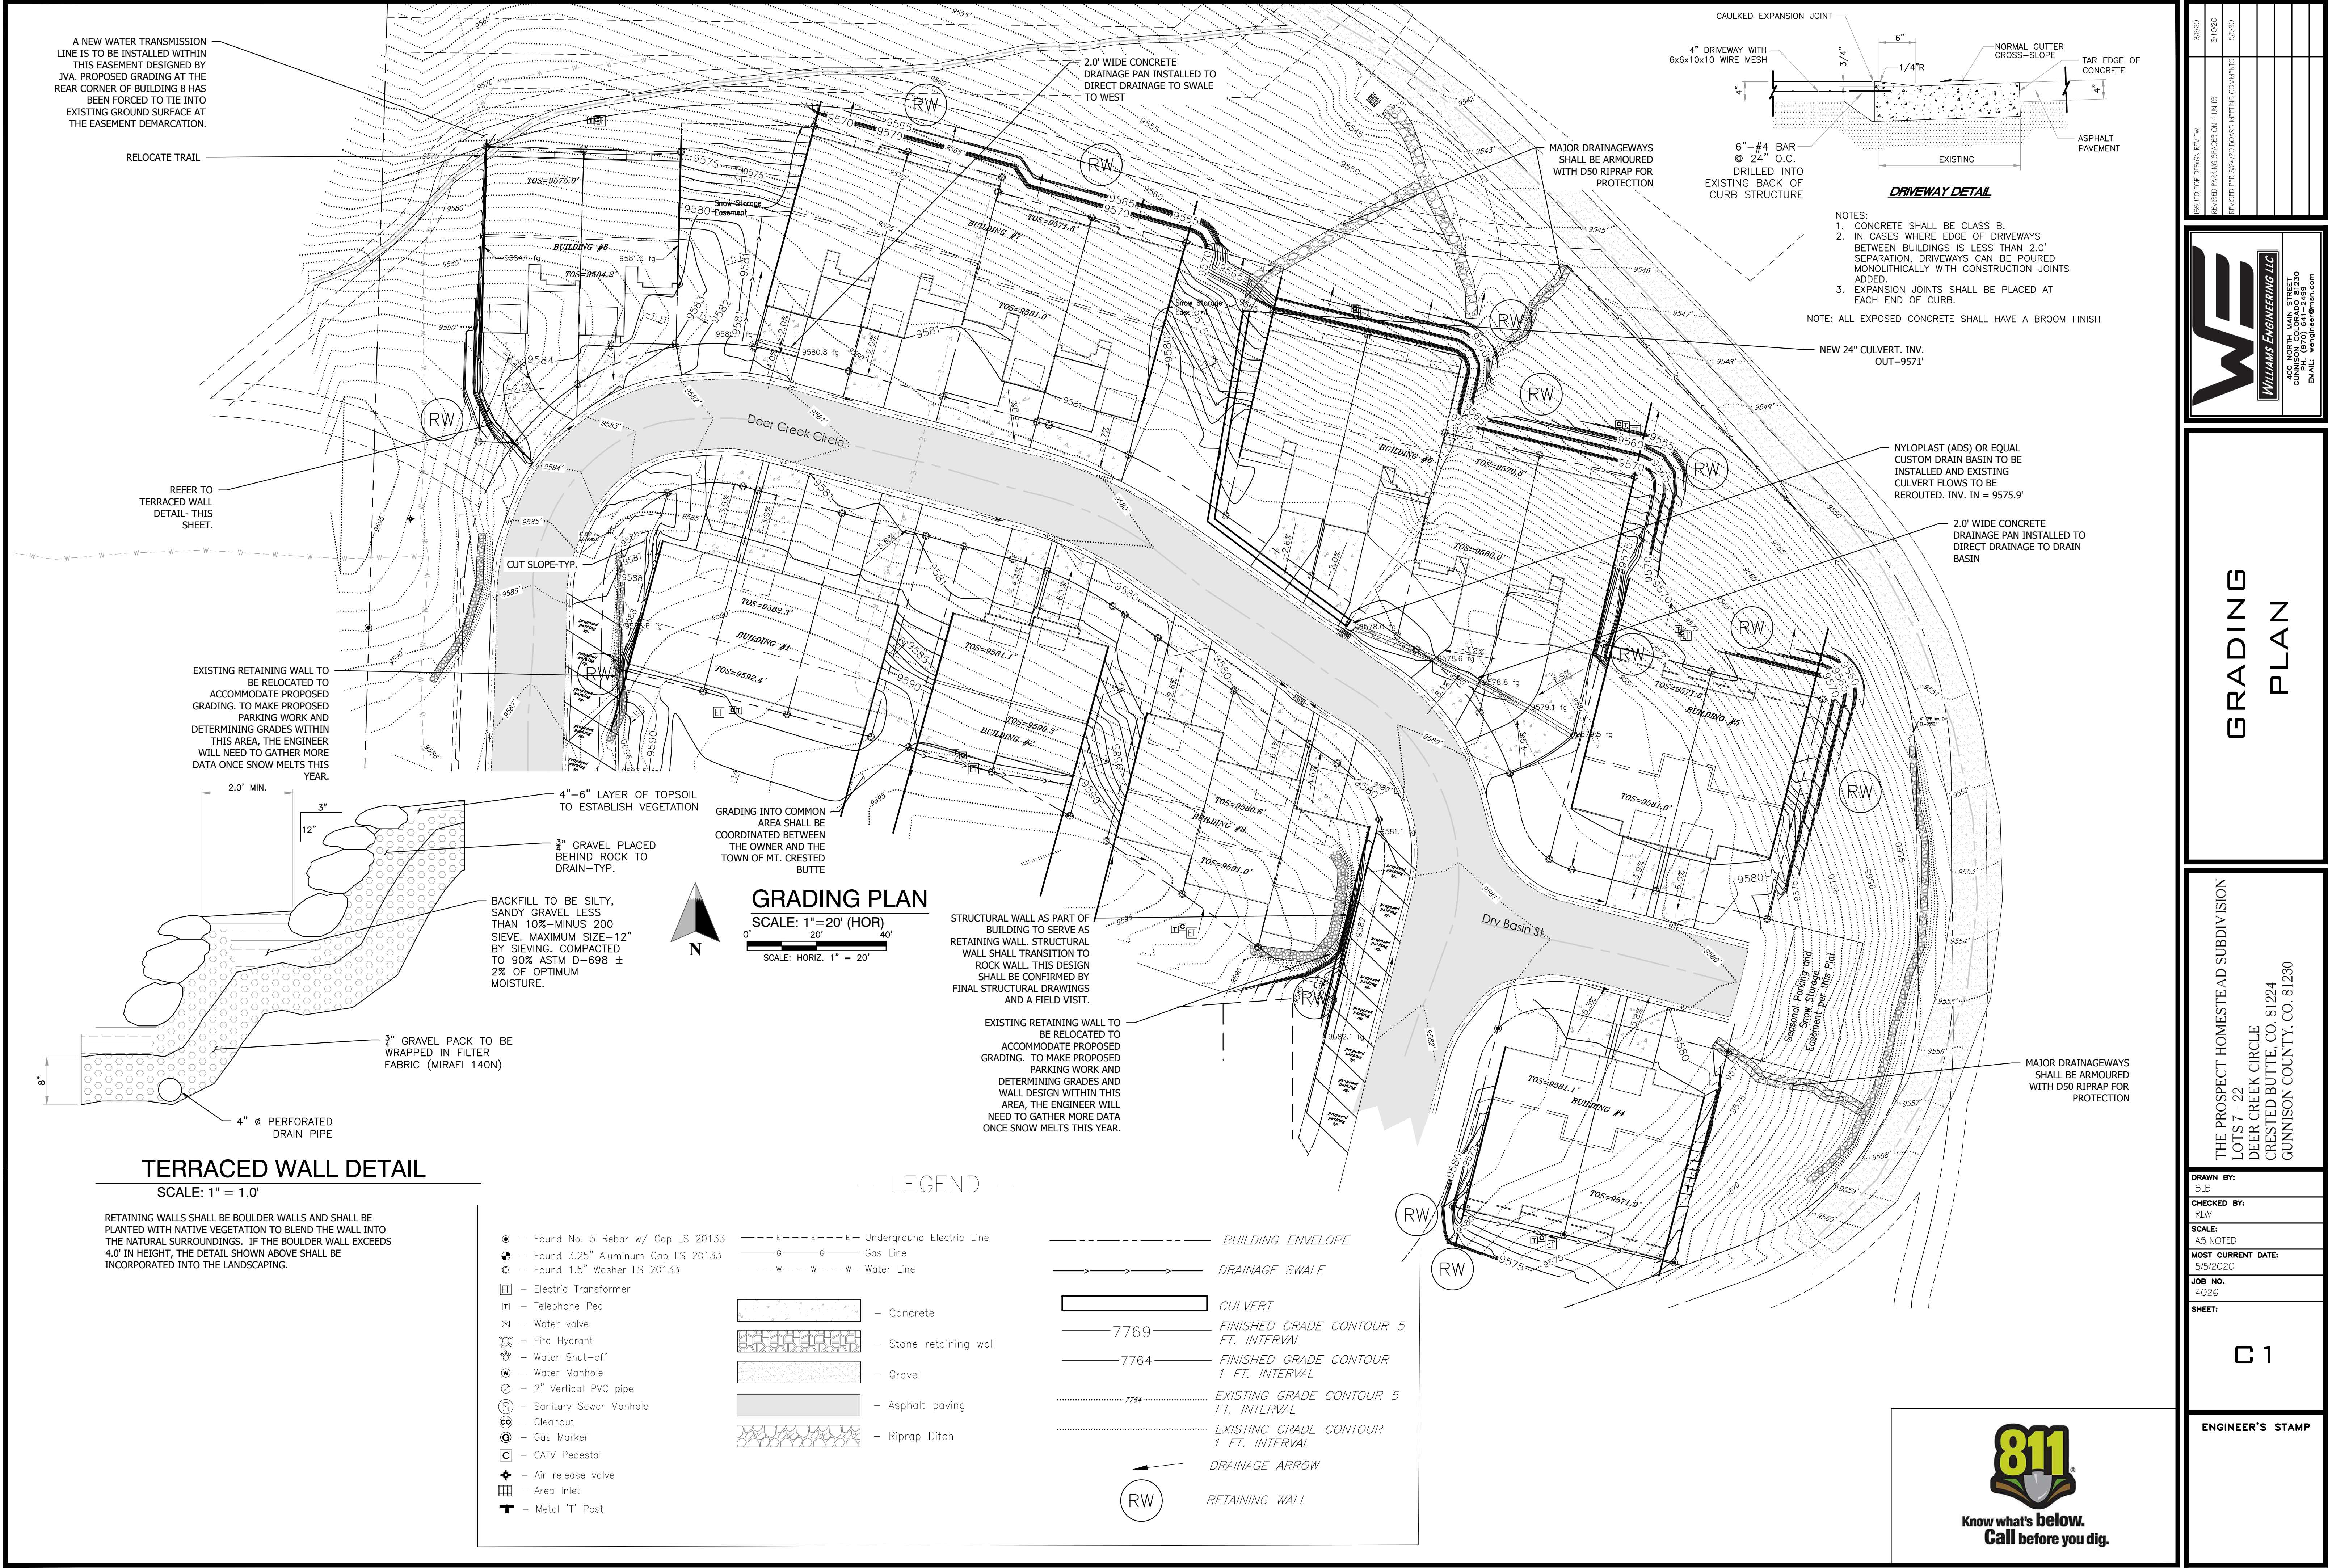

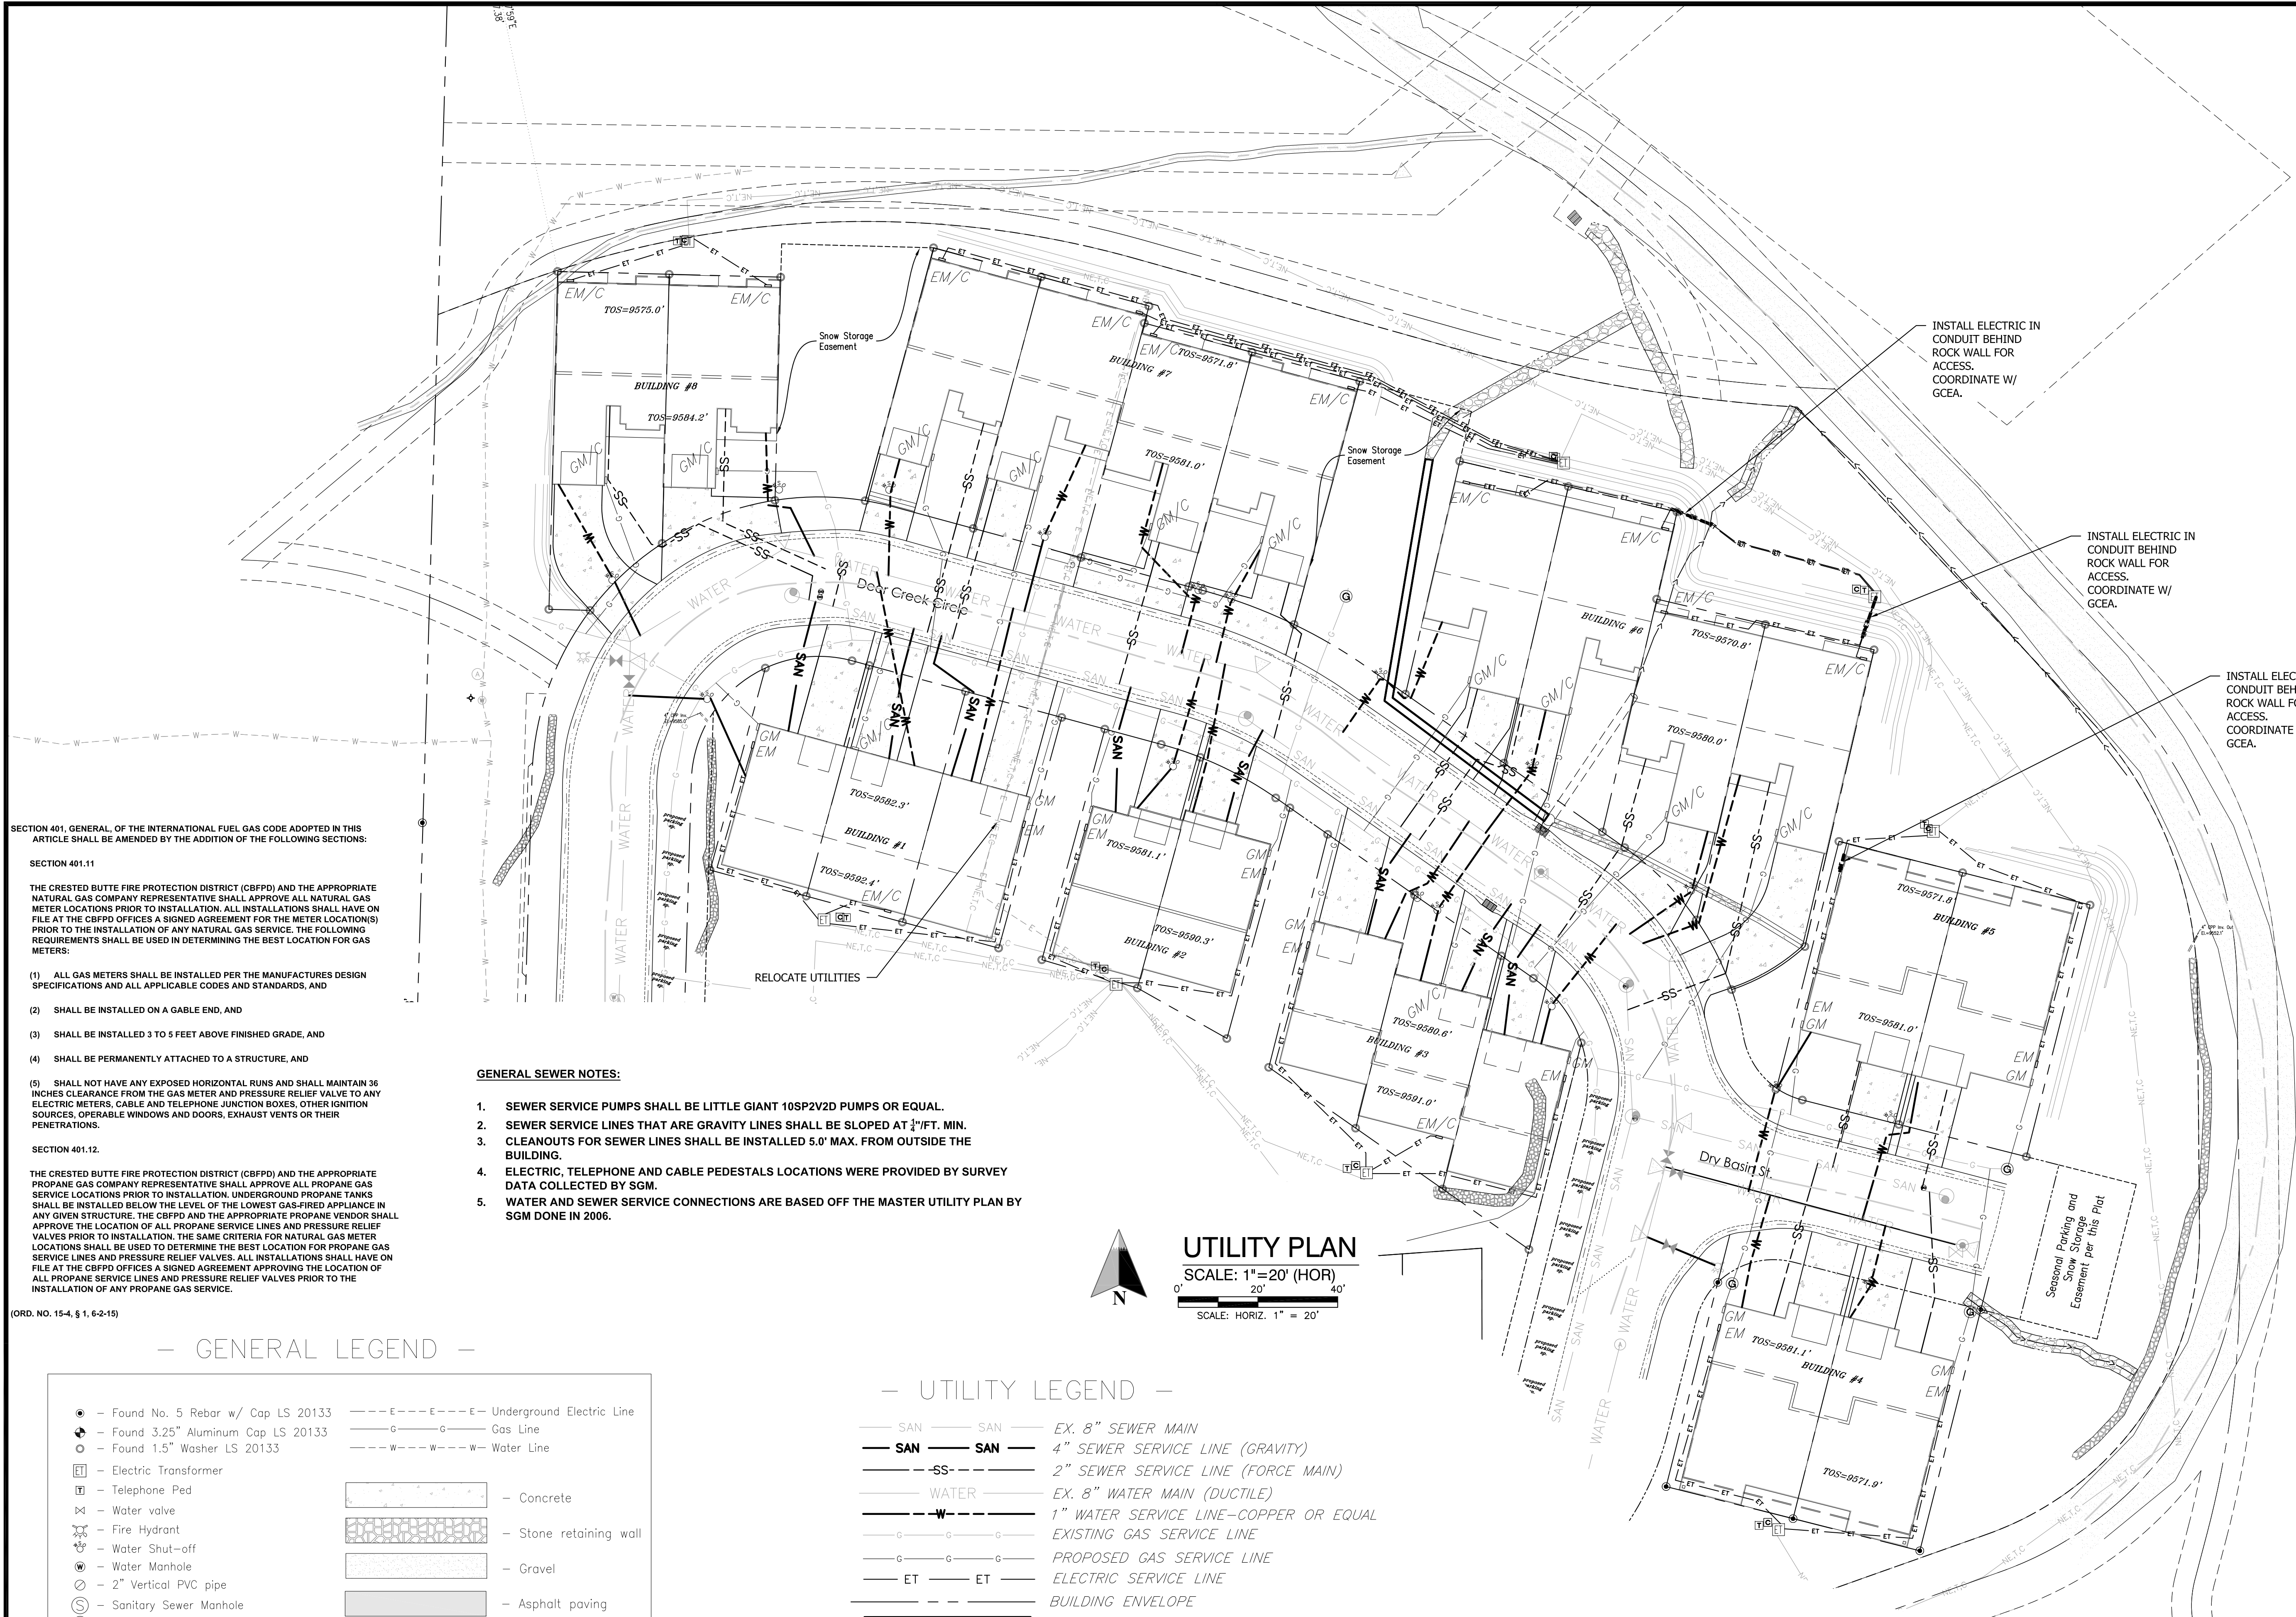

SECTION 401. GENERAL, OF THE INTERNATIONAL FUEL GAS CODE ADOPTED IN THIS ARTICLE SHALL BE AMENDED BY THE ADDITION OF THE FOLLOWING SECTIONS:

SECTION 401.11

THE CRESTED BUTTE FIRE PROTECTION DISTRICT (CBFPD) AND THE APPROPRIATE NATURAL GAS COMPANY REPRESENTATIVE SHALL APPROVE ALL NATURAL GAS METER LOCATIONS PRIOR TO INSTALLATION. ALL INSTALLATIONS SHALL HAVE ON FILE AT THE CBFPD OFFICES A SIGNED AGREEMENT FOR THE METER LOCATION(S) PRIOR TO THE INSTALLATION OF ANY NATURAL GAS SERVICE. THE FOLLOWING REQUIREMENTS SHALL BE USED IN DETERMINING THE BEST LOCATION FOR GAS METERS:

- (1) ALL GAS METERS SHALL BE INSTALLED PER THE MANUFACTURES DESIGN SPECIFICATIONS AND ALL APPLICABLE CODES AND STANDARDS, AND
- (2) SHALL BE INSTALLED ON A GABLE END, AND
- (3) SHALL BE INSTALLED 3 TO 5 FEET ABOVE FINISHED GRADE, AND
- (4) SHALL BE PERMANENTLY ATTACHED TO A STRUCTURE, AND


SECTION 401.12.

THE CRESTED BUTTE FIRE PROTECTION DISTRICT (CBFPD) AND THE APPROPRIATE PROPANE GAS COMPANY REPRESENTATIVE SHALL APPROVE ALL PROPANE GAS SERVICE LOCATIONS PRIOR TO INSTALLATION. UNDERGROUND PROPANE TANKS SHALL BE INSTALLED BELOW THE LEVEL OF THE LOWEST GAS-FIRED APPLIANCE IN ANY GIVEN STRUCTURE. THE CBFPD AND THE APPROPRIATE PROPANE VENDOR SHALL APPROVE THE LOCATION OF ALL PROPANE SERVICE LINES AND PRESSURE RELIEF VALVES PRIOR TO INSTALLATION. THE SAME CRITERIA FOR NATURAL GAS METER LOCATIONS SHALL BE USED TO DETERMINE THE BEST LOCATION FOR PROPANE GAS SERVICE LINES AND PRESSURE RELIEF VALVES. ALL INSTALLATIONS SHALL HAVE ON FILE AT THE CBFPD OFFICES A SIGNED AGREEMENT APPROVING THE LOCATION OF ALL PROPANE SERVICE LINES AND PRESSURE RELIEF VALVES PRIOR TO THE INSTALLATION OF ANY PROPANE GAS SERVICE.

(ORD. NO. 15-4, § 1, 6-2-15)

GENERAL SEWER NOTES:

1. SEWER SERVICE PUMPS SHALL BE LITTLE GIANT 10SP2V2D PUMPS OR EQUAL.
2. SEWER SERVICE LINES THAT ARE GRAVITY LINES SHALL BE SLOPED AT  $\frac{1}{4}$ "/FT. MIN.
3. CLEANOUTS FOR SEWER LINES SHALL BE INSTALLED 5.0' MAX. FROM OUTSIDE THE BUILDING.
4. ELECTRIC, TELEPHONE AND CABLE PEDESTALS LOCATIONS WERE PROVIDED BY SURVEY DATA COLLECTED BY SGM.
5. WATER AND SEWER SERVICE CONNECTIONS ARE BASED OFF THE MASTER UTILITY PLAN BY SGM DONE IN 2006.

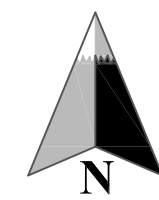

UTILITY PLAN  
SCALE: 1"=20' (HOR)  
0' 20' 40'  
SCALE: HORIZ. 1" = 20'

— GENERAL LEGEND —

|                                     |                                           |
|-------------------------------------|-------------------------------------------|
| ● Found No. 5 Rebar w/ Cap LS 20133 | ---E---E---E--- Underground Electric Line |
| ● Found 3.25" Aluminum Cap LS 20133 | ---G---G---G--- Gas Line                  |
| ○ Found 1.5" Washer LS 20133        | ---W---W---W--- Water Line                |
| ⏏ Electric Transformer              |                                           |
| ⏏ Telephone Ped                     | Concrete                                  |
| ⏏ Water valve                       | Stone retaining wall                      |
| ⏏ Fire Hydrant                      | Gravel                                    |
| ⏏ Water Shut-off                    | Asphalt paving                            |
| ⏏ Water Manhole                     | Riprap Ditch                              |
| ⏏ 2" Vertical PVC pipe              |                                           |
| ⏏ Sanitary Sewer Manhole            |                                           |
| ⏏ Cleanout                          |                                           |
| ⏏ Gas Marker                        |                                           |
| ⏏ CATV Pedestal                     |                                           |
| ⏏ Air release valve                 |                                           |
| ⏏ Area Inlet                        |                                           |
| ⏏ Metal "T" Post                    |                                           |

— UTILITY LEGEND —

|       |       |                                          |
|-------|-------|------------------------------------------|
| SAN   | SAN   | EX. 8" SEWER MAIN                        |
| SAN   | SAN   | 4" SEWER SERVICE LINE (GRAVITY)          |
| SS    | SS    | 2" SEWER SERVICE LINE (FORCE MAIN)       |
| WATER | WATER | EX. 8" WATER MAIN (DUCTILE)              |
| W     | W     | 1" WATER SERVICE LINE—COPPER OR EQUAL    |
| G     | G     | EXISTING GAS SERVICE LINE                |
| G     | G     | PROPOSED GAS SERVICE LINE                |
| ET    | ET    | ELECTRIC SERVICE LINE                    |
|       |       | BUILDING ENVELOPE                        |
|       |       | CULVERT                                  |
| GM    |       | GAS METER                                |
| GM/C  |       | GAS METER W/ COVER (SNOW PROTECTION)     |
| EM    |       | ELECTRIC METER                           |
| EM/C  |       | ELECTRIC METER W/COVER (SNOW PROTECTION) |

|          |                                            |
|----------|--------------------------------------------|
| 3/2020   | ISSUED FOR DESIGN REVIEW                   |
| 3/1/2020 | REVISED PARKING SPACES ON 4 UNITS          |
| 5/5/20   | REVISED PER 3/24/20 BOARD MEETING COMMENTS |
|          |                                            |
|          |                                            |
|          |                                            |
|          |                                            |
|          |                                            |



UTILITY  
PLAN

THE PROSPECT HOMESTEAD SUBDIVISION  
LOTS 7 - 22  
DEER CREEK CIRCLE  
CRESTED BUTTE, CO. 81224  
GUNNISON COUNTY, CO. 81230

|                    |          |
|--------------------|----------|
| DRAWN BY:          | SLB      |
| CHECKED BY:        | RLW      |
| SCALE:             | AS NOTED |
| MOST CURRENT DATE: | 5/5/2020 |
| JOB NO.            | 4026     |
| SHEET:             |          |

C3


ENGINEER'S STAMP








building 1 right PROFILE

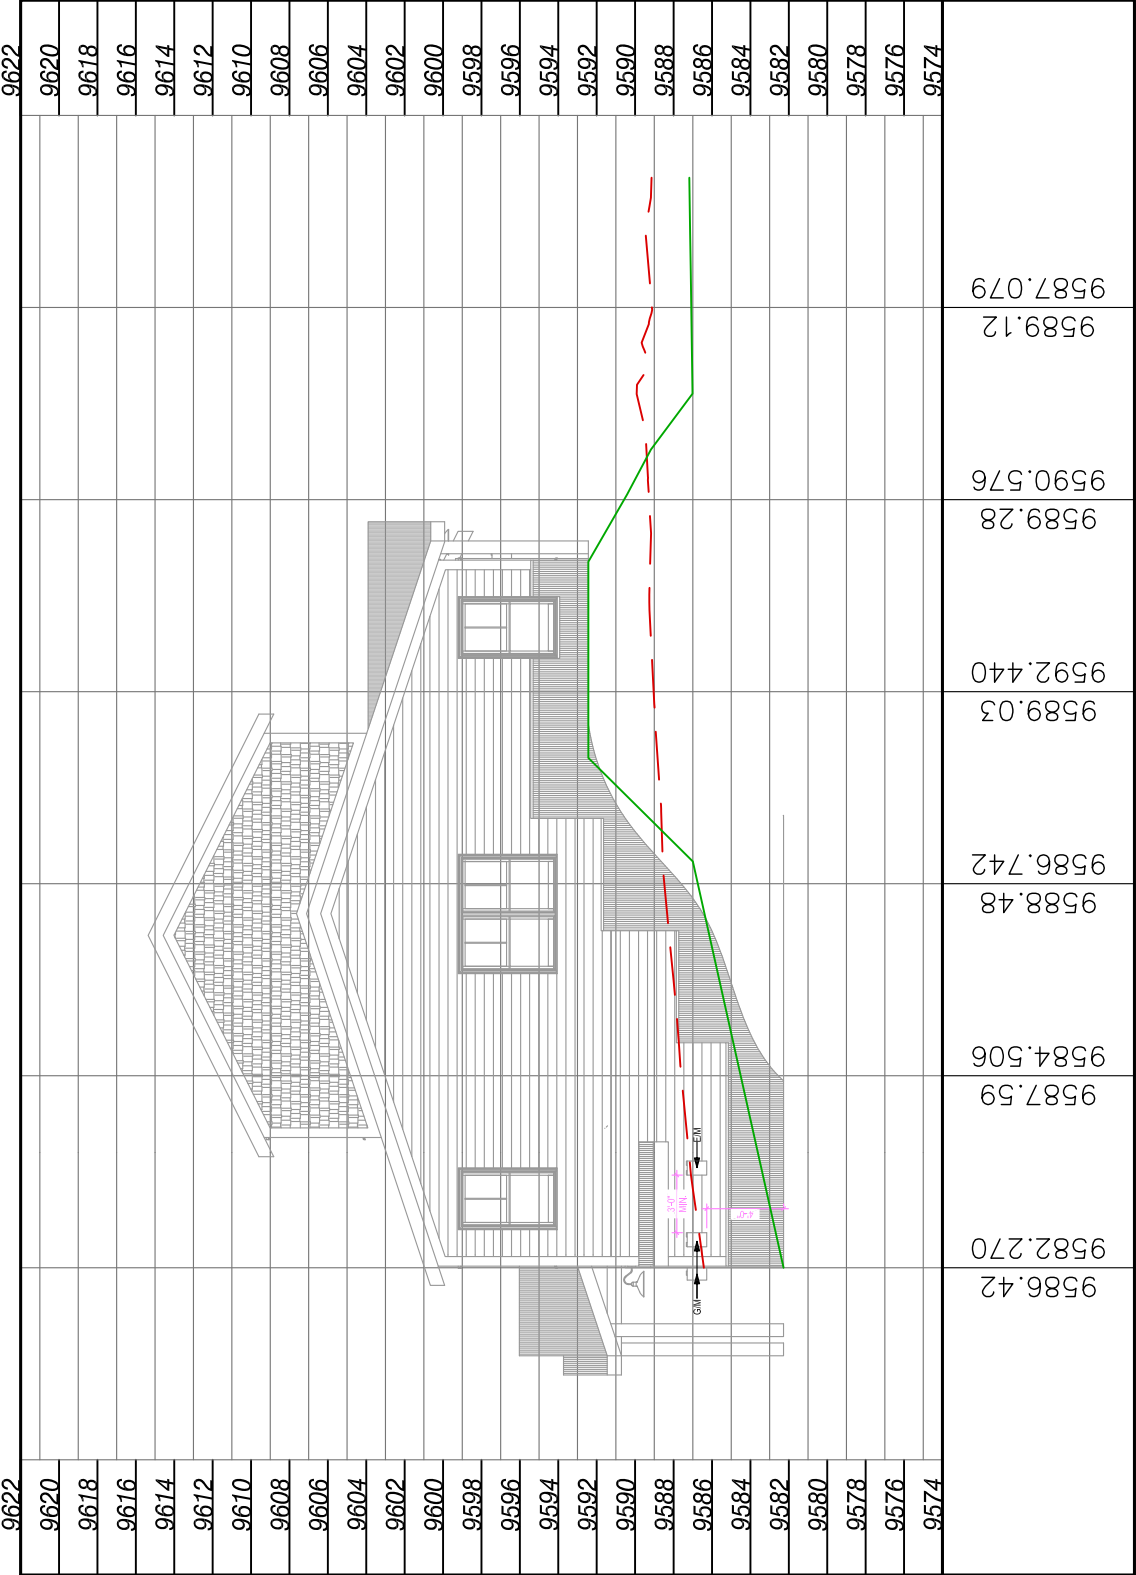

building 2 right PROFILE

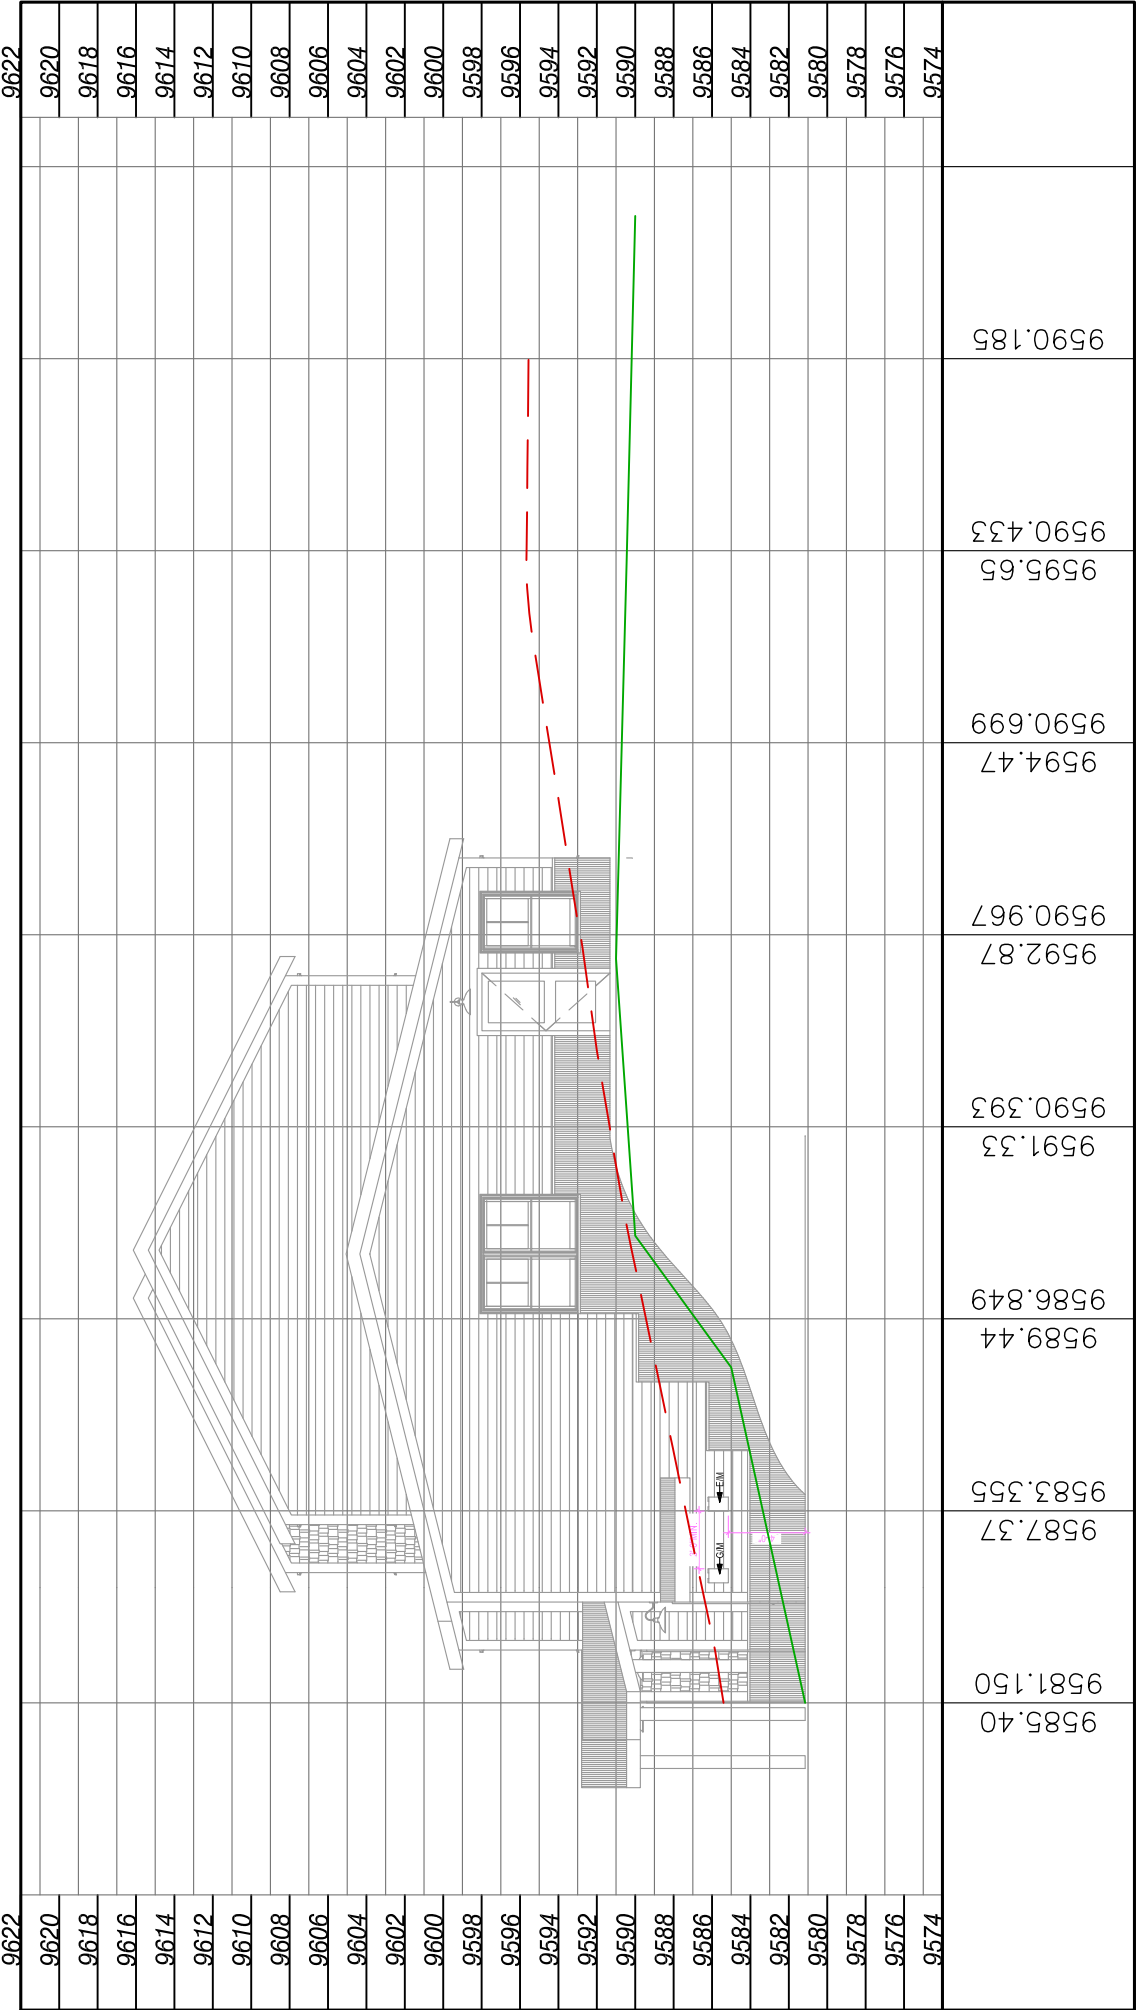

building 1 left PROFILE



building 2 left PROFILE



ENGINEER'S STAMP

G 1

THE PROSPECT HOMESTEAD SUBDIVISION  
LOTS 7 - 22  
DEER CREEK CIRCLE  
CRESTED BUTTE, COLORADO 81224  
GUNNISON COUNTY, COLORADO 81230

DRAWN BY:  
313  
CHECKED BY:  
RSM  
SCALE:  
AS NOTED  
MOST CURRENT DATE:  
2/23/2020  
JOB NO.  
3044

**WE**  
**WILLIAMS ENGINEERING LLC**  
400 NORTH MAIN STREET  
GUNNISON, COLORADO 81230  
PHONE: 970.244.8111  
EMAIL: [engineering@williams-engineering.com](mailto:engineering@williams-engineering.com)



Know what's below.  
Call before you dig.

# GRADING PLAN BUILDING 1 & 2


ISSUED FOR DESIGN REVIEW

2/24/20









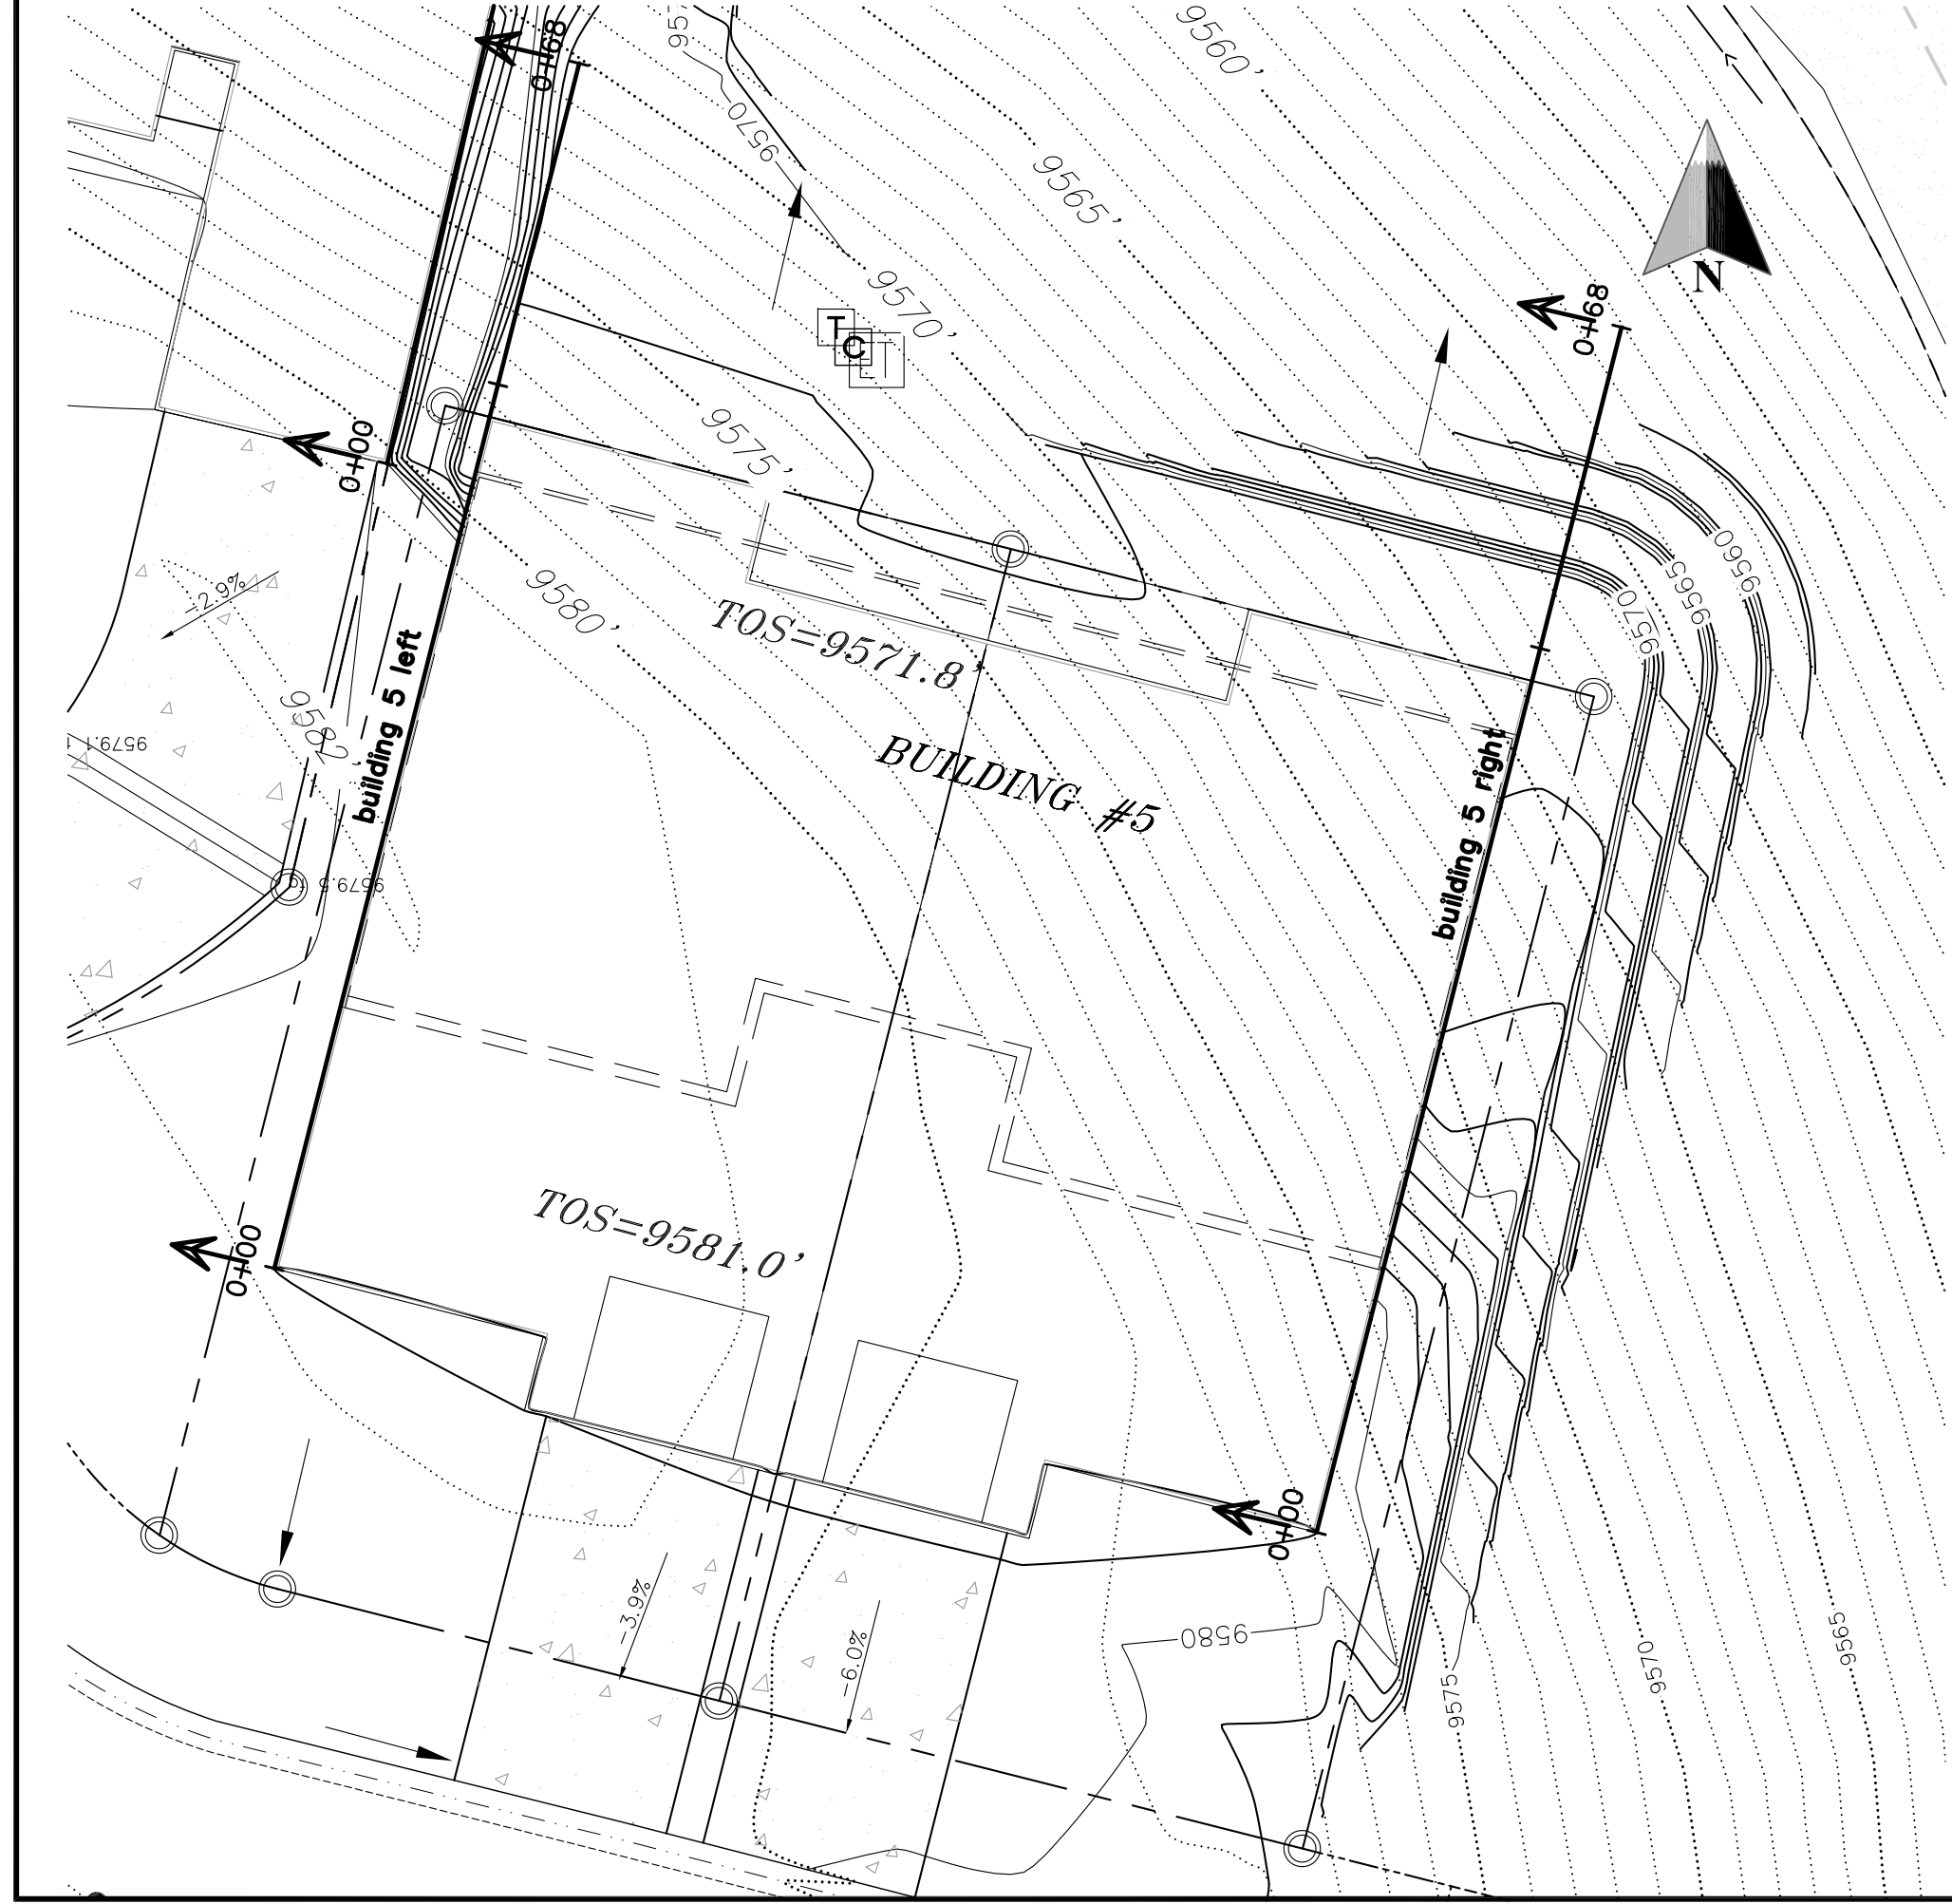


building 5 left PROFILE

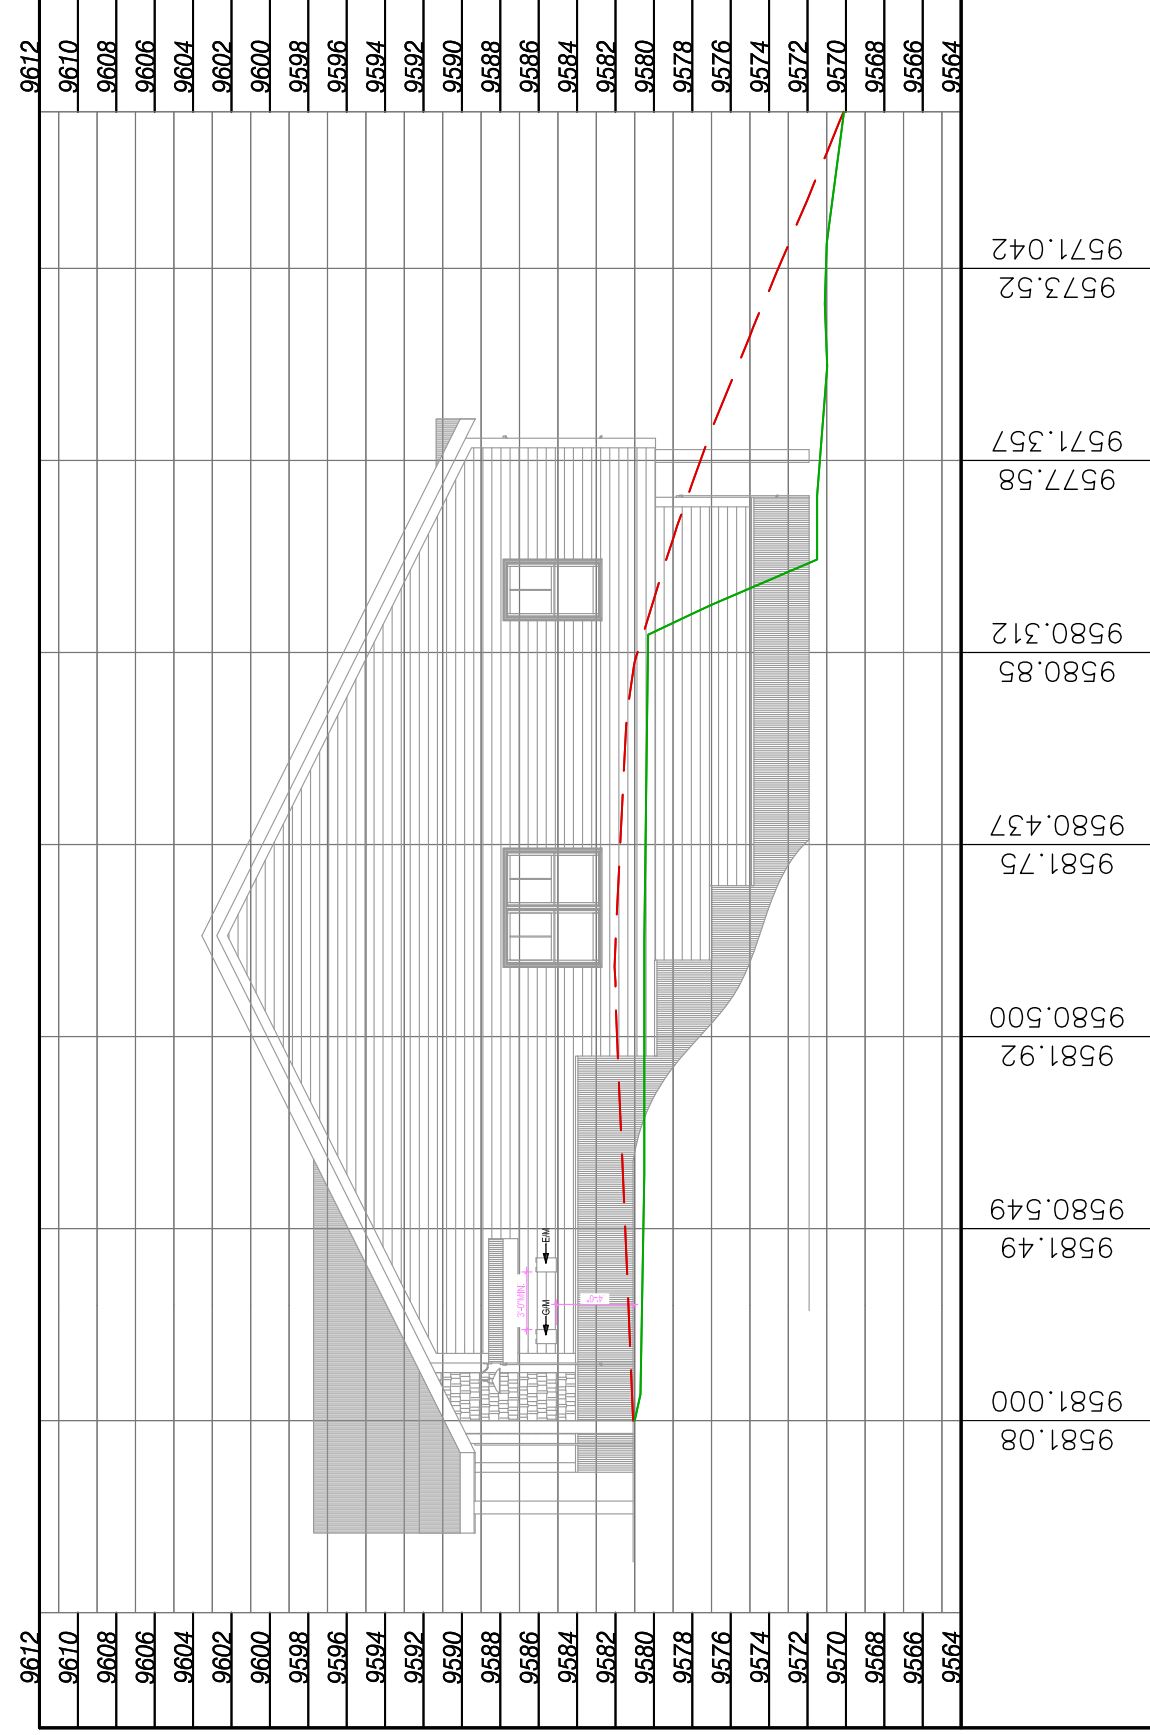


building 6 left PROFILE

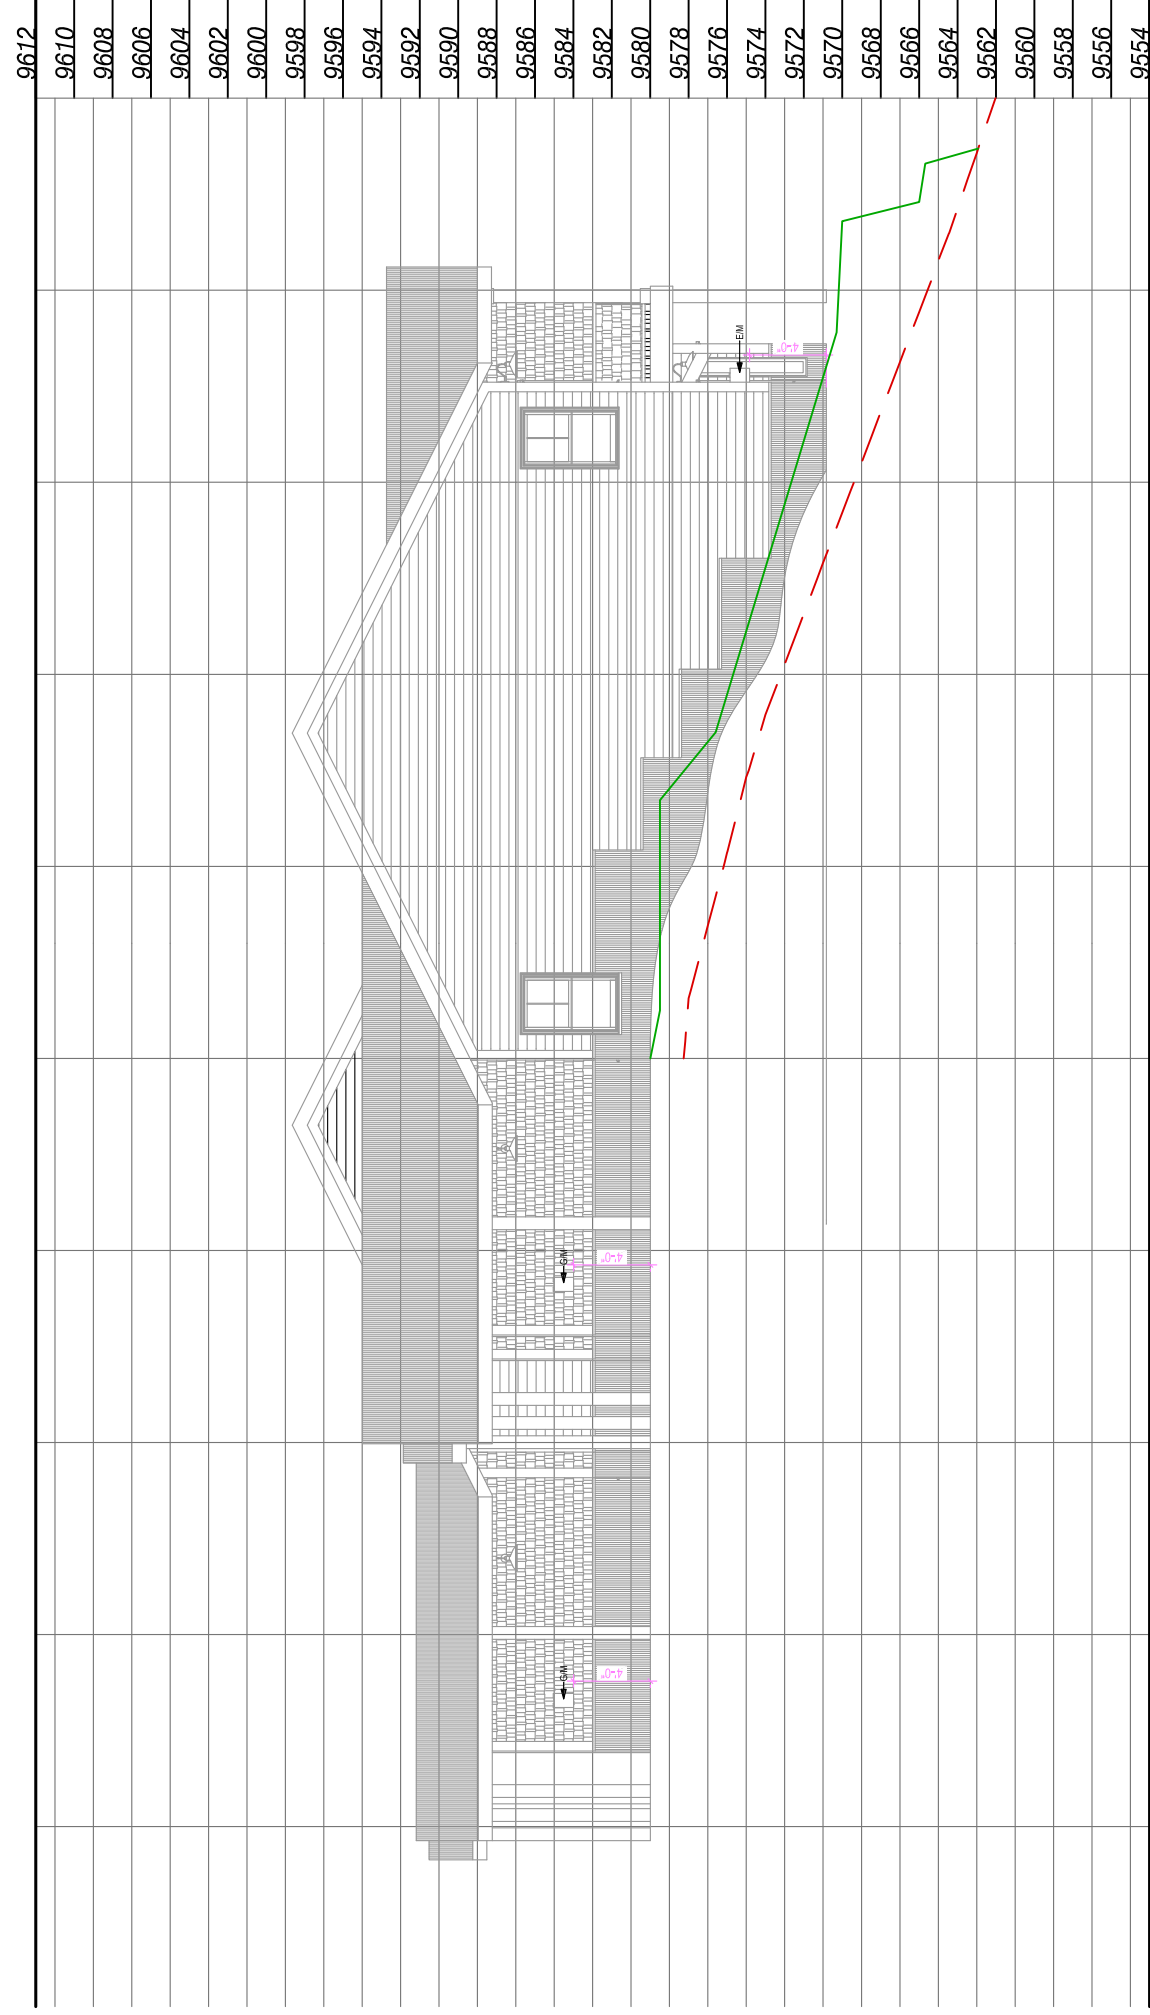

building 5 right PROFILE

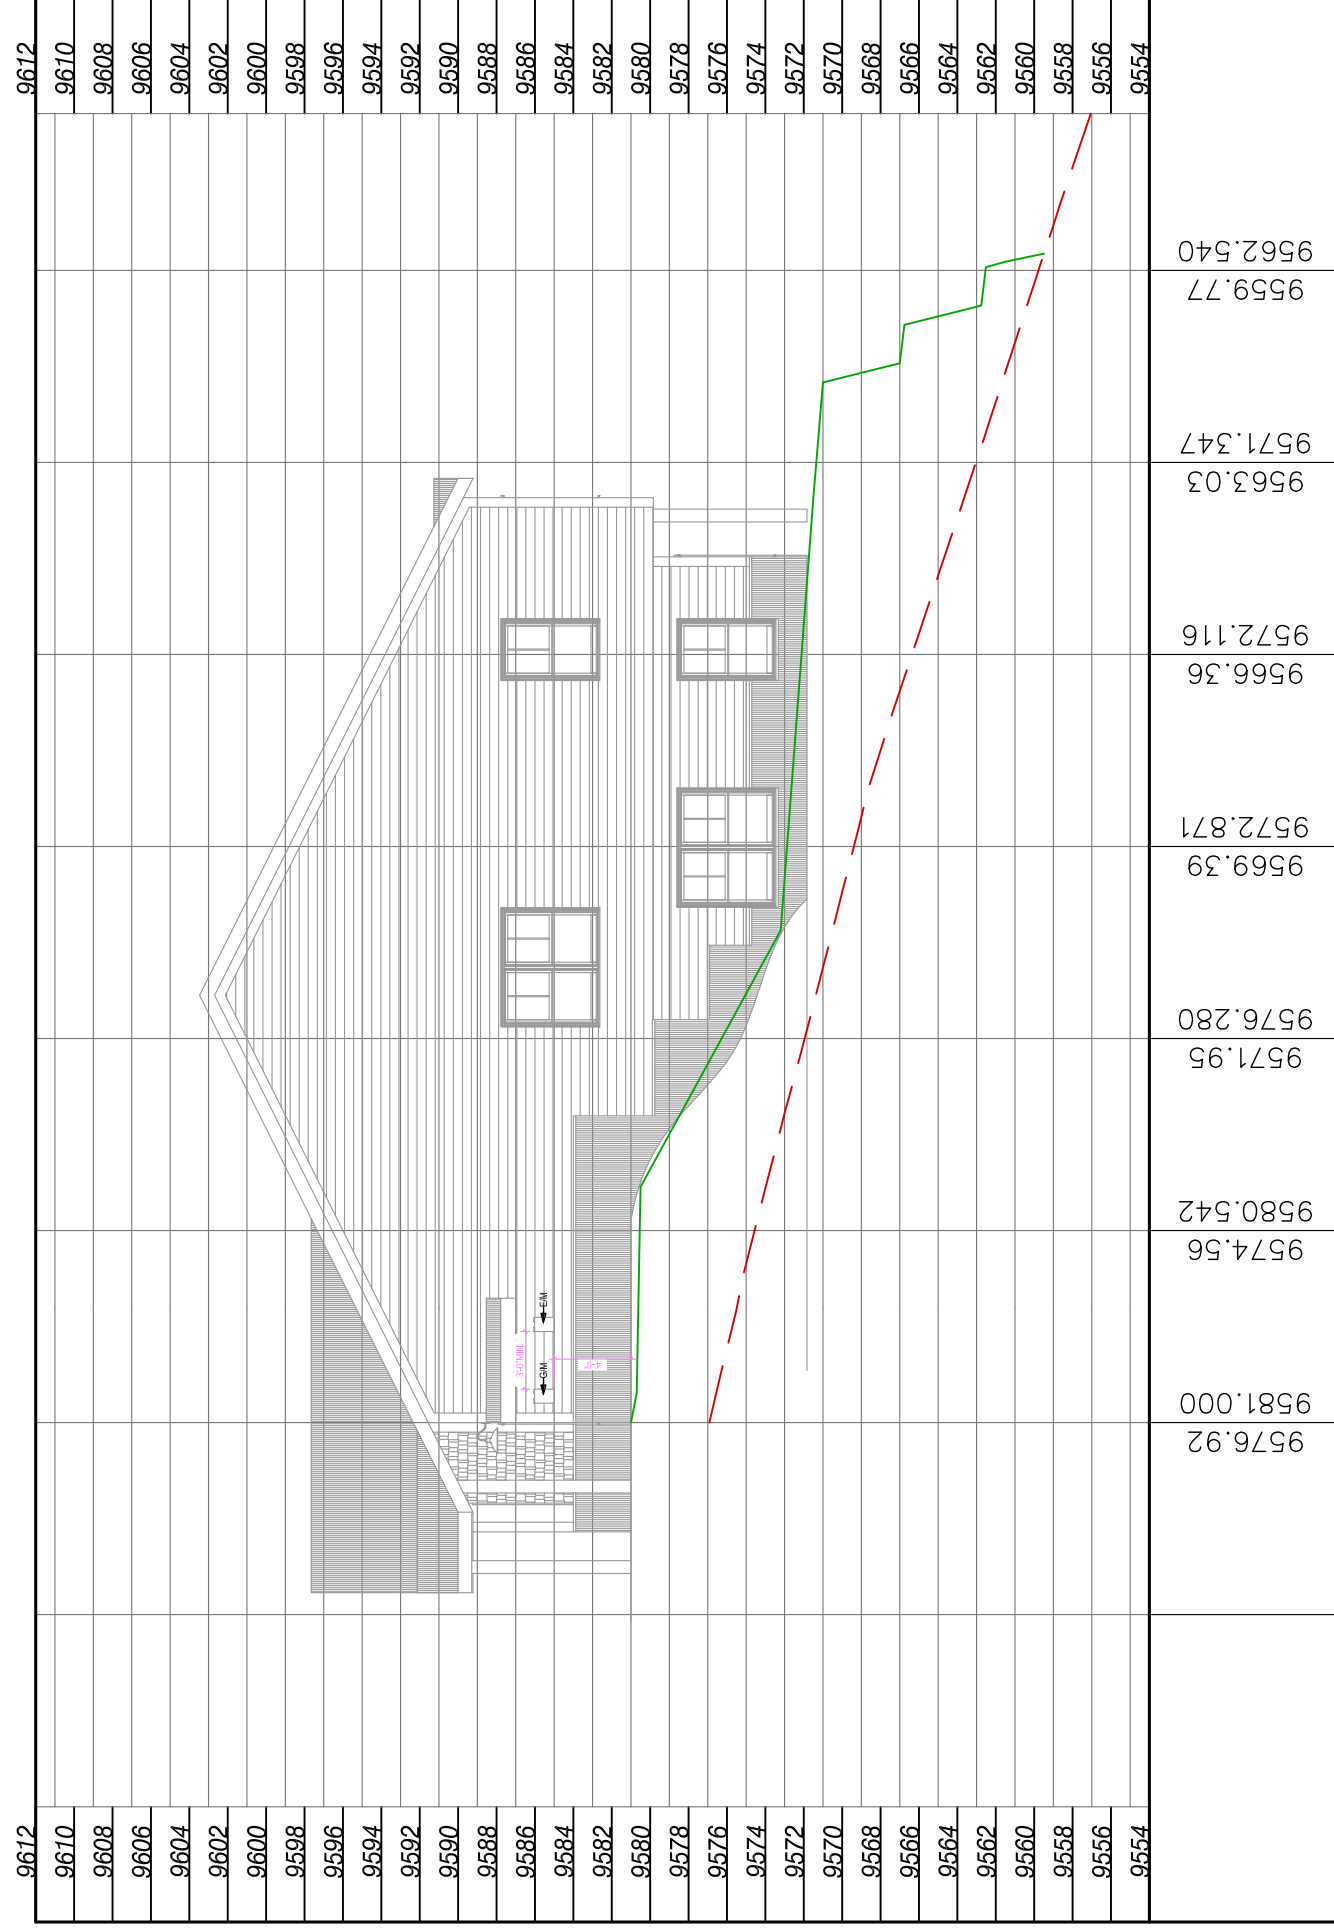

building 6 right PROFILE

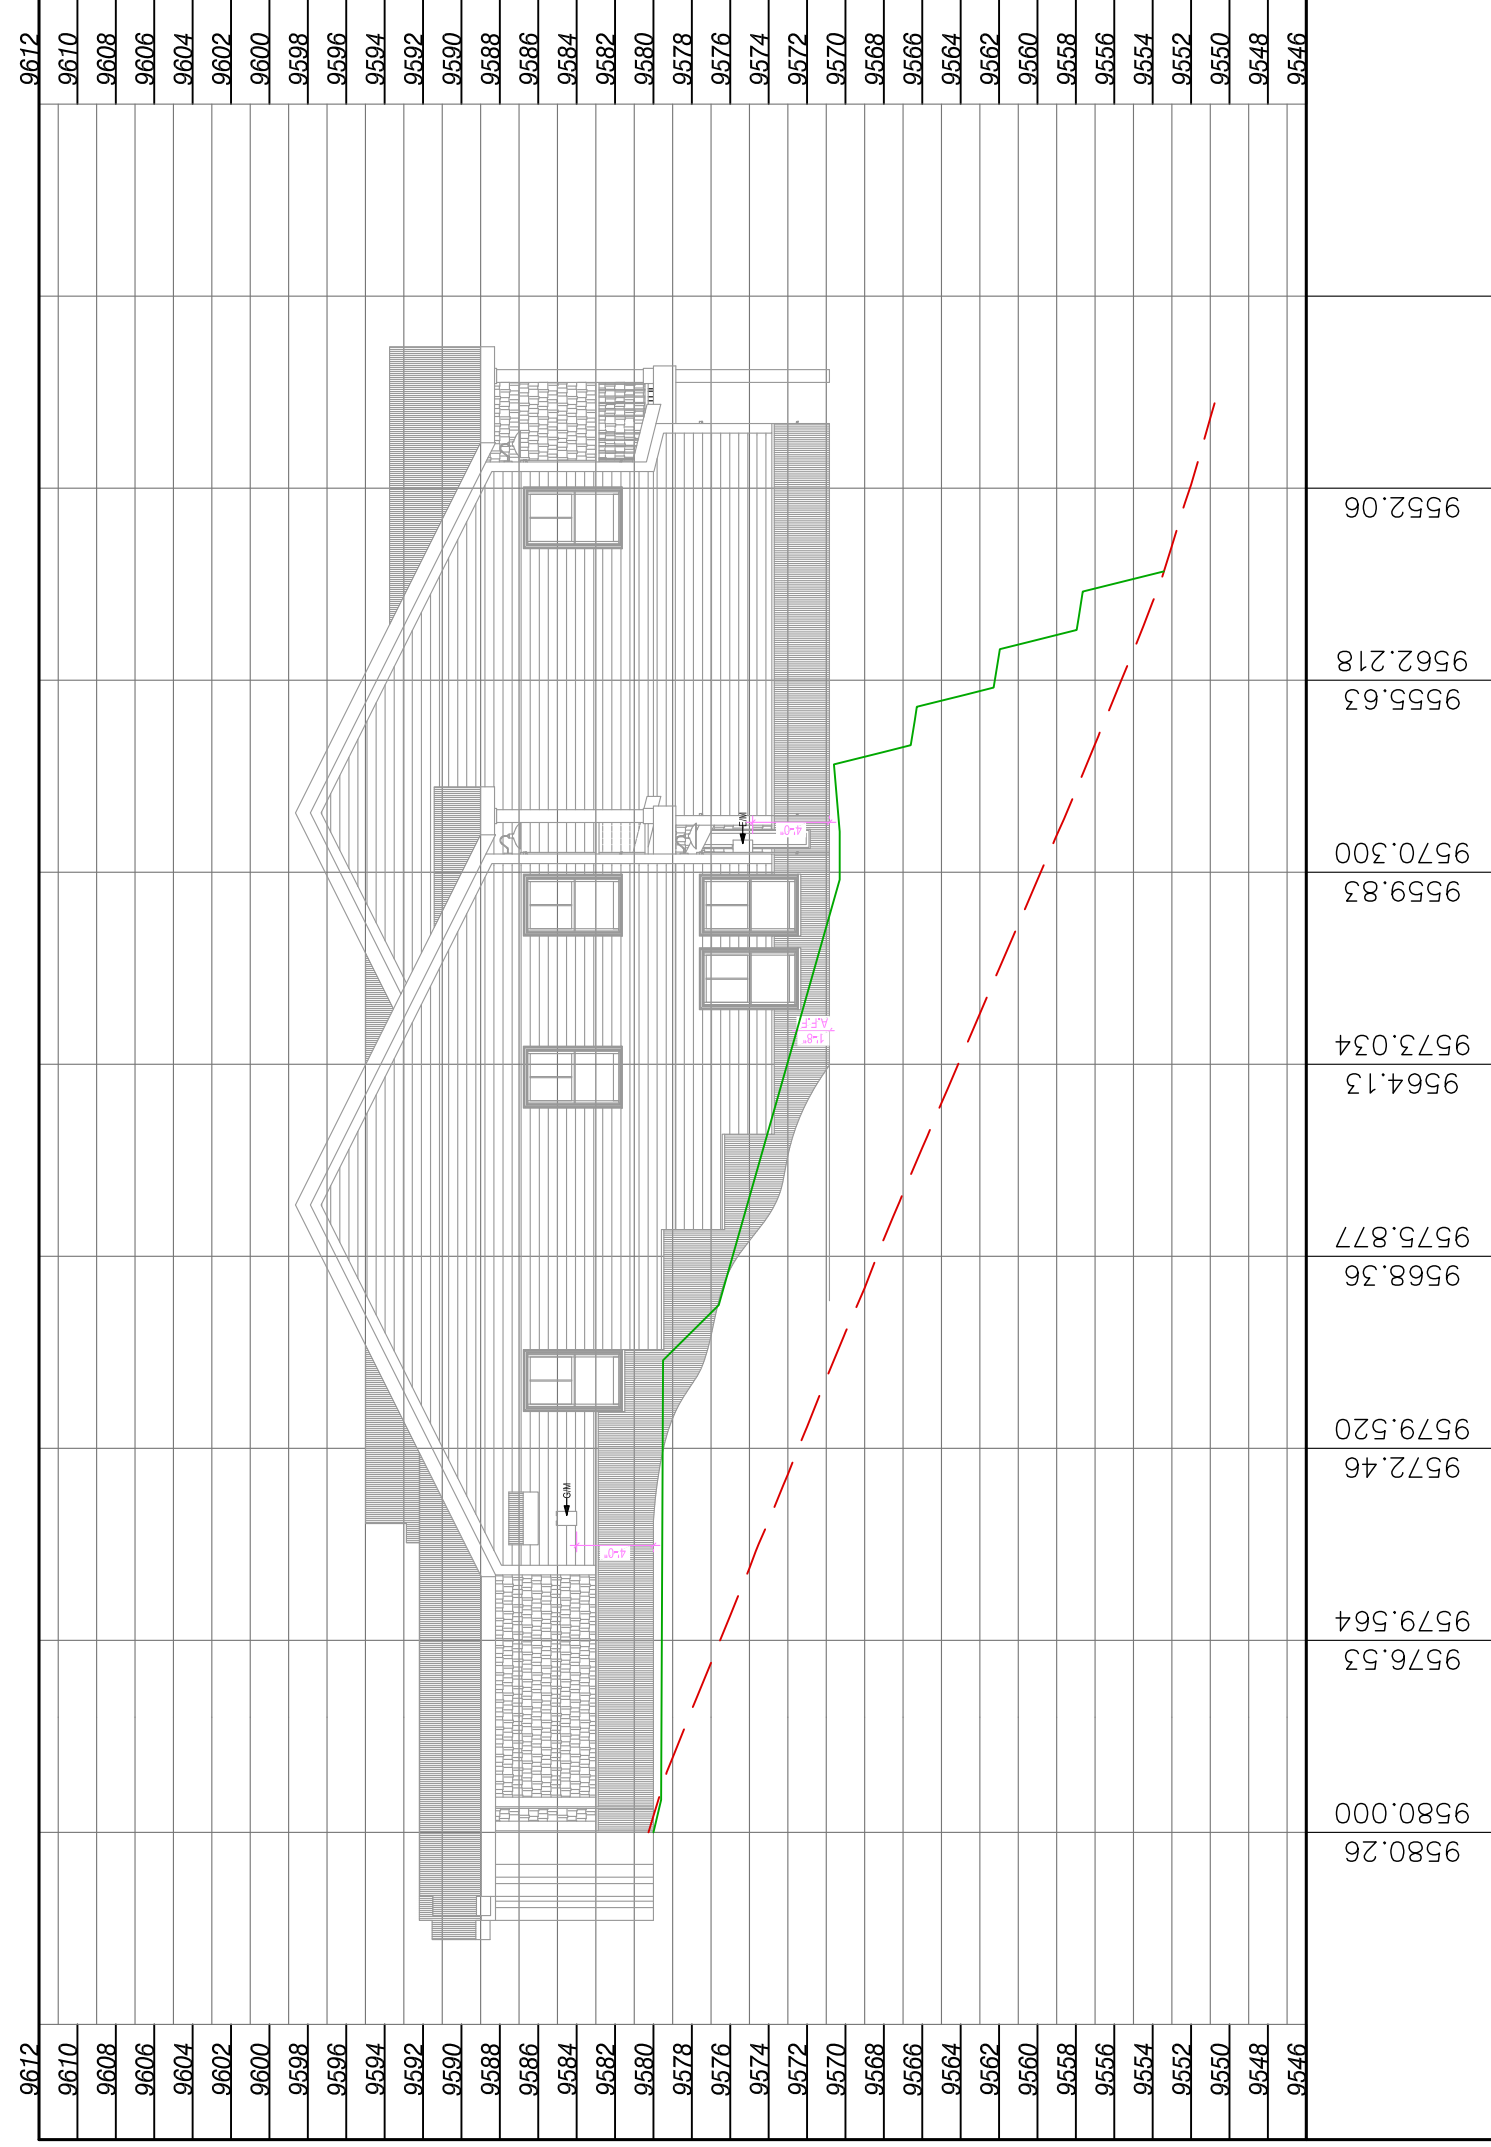

ENGINEER'S STAMP

SHEET:

G 3

THE PROSPECT HOMESTEAD SUBDIVISION  
LOTS 7 - 22  
DEER CREEK CIRCLE  
CRESTED BUTTE, COLORADO 81224  
GUNNISON COUNTY, COLORADO 81230

DRAWN BY:

3/13

CHECKED BY:

RLM

SCALE:

AS NOTED

MOST CURRENT DATE:

22-42520

JOB NO.

35-44




# GRADING PLAN BUILDING 5 & 6


DESIGNED FOR DESIGN REVIEW

2/24/20





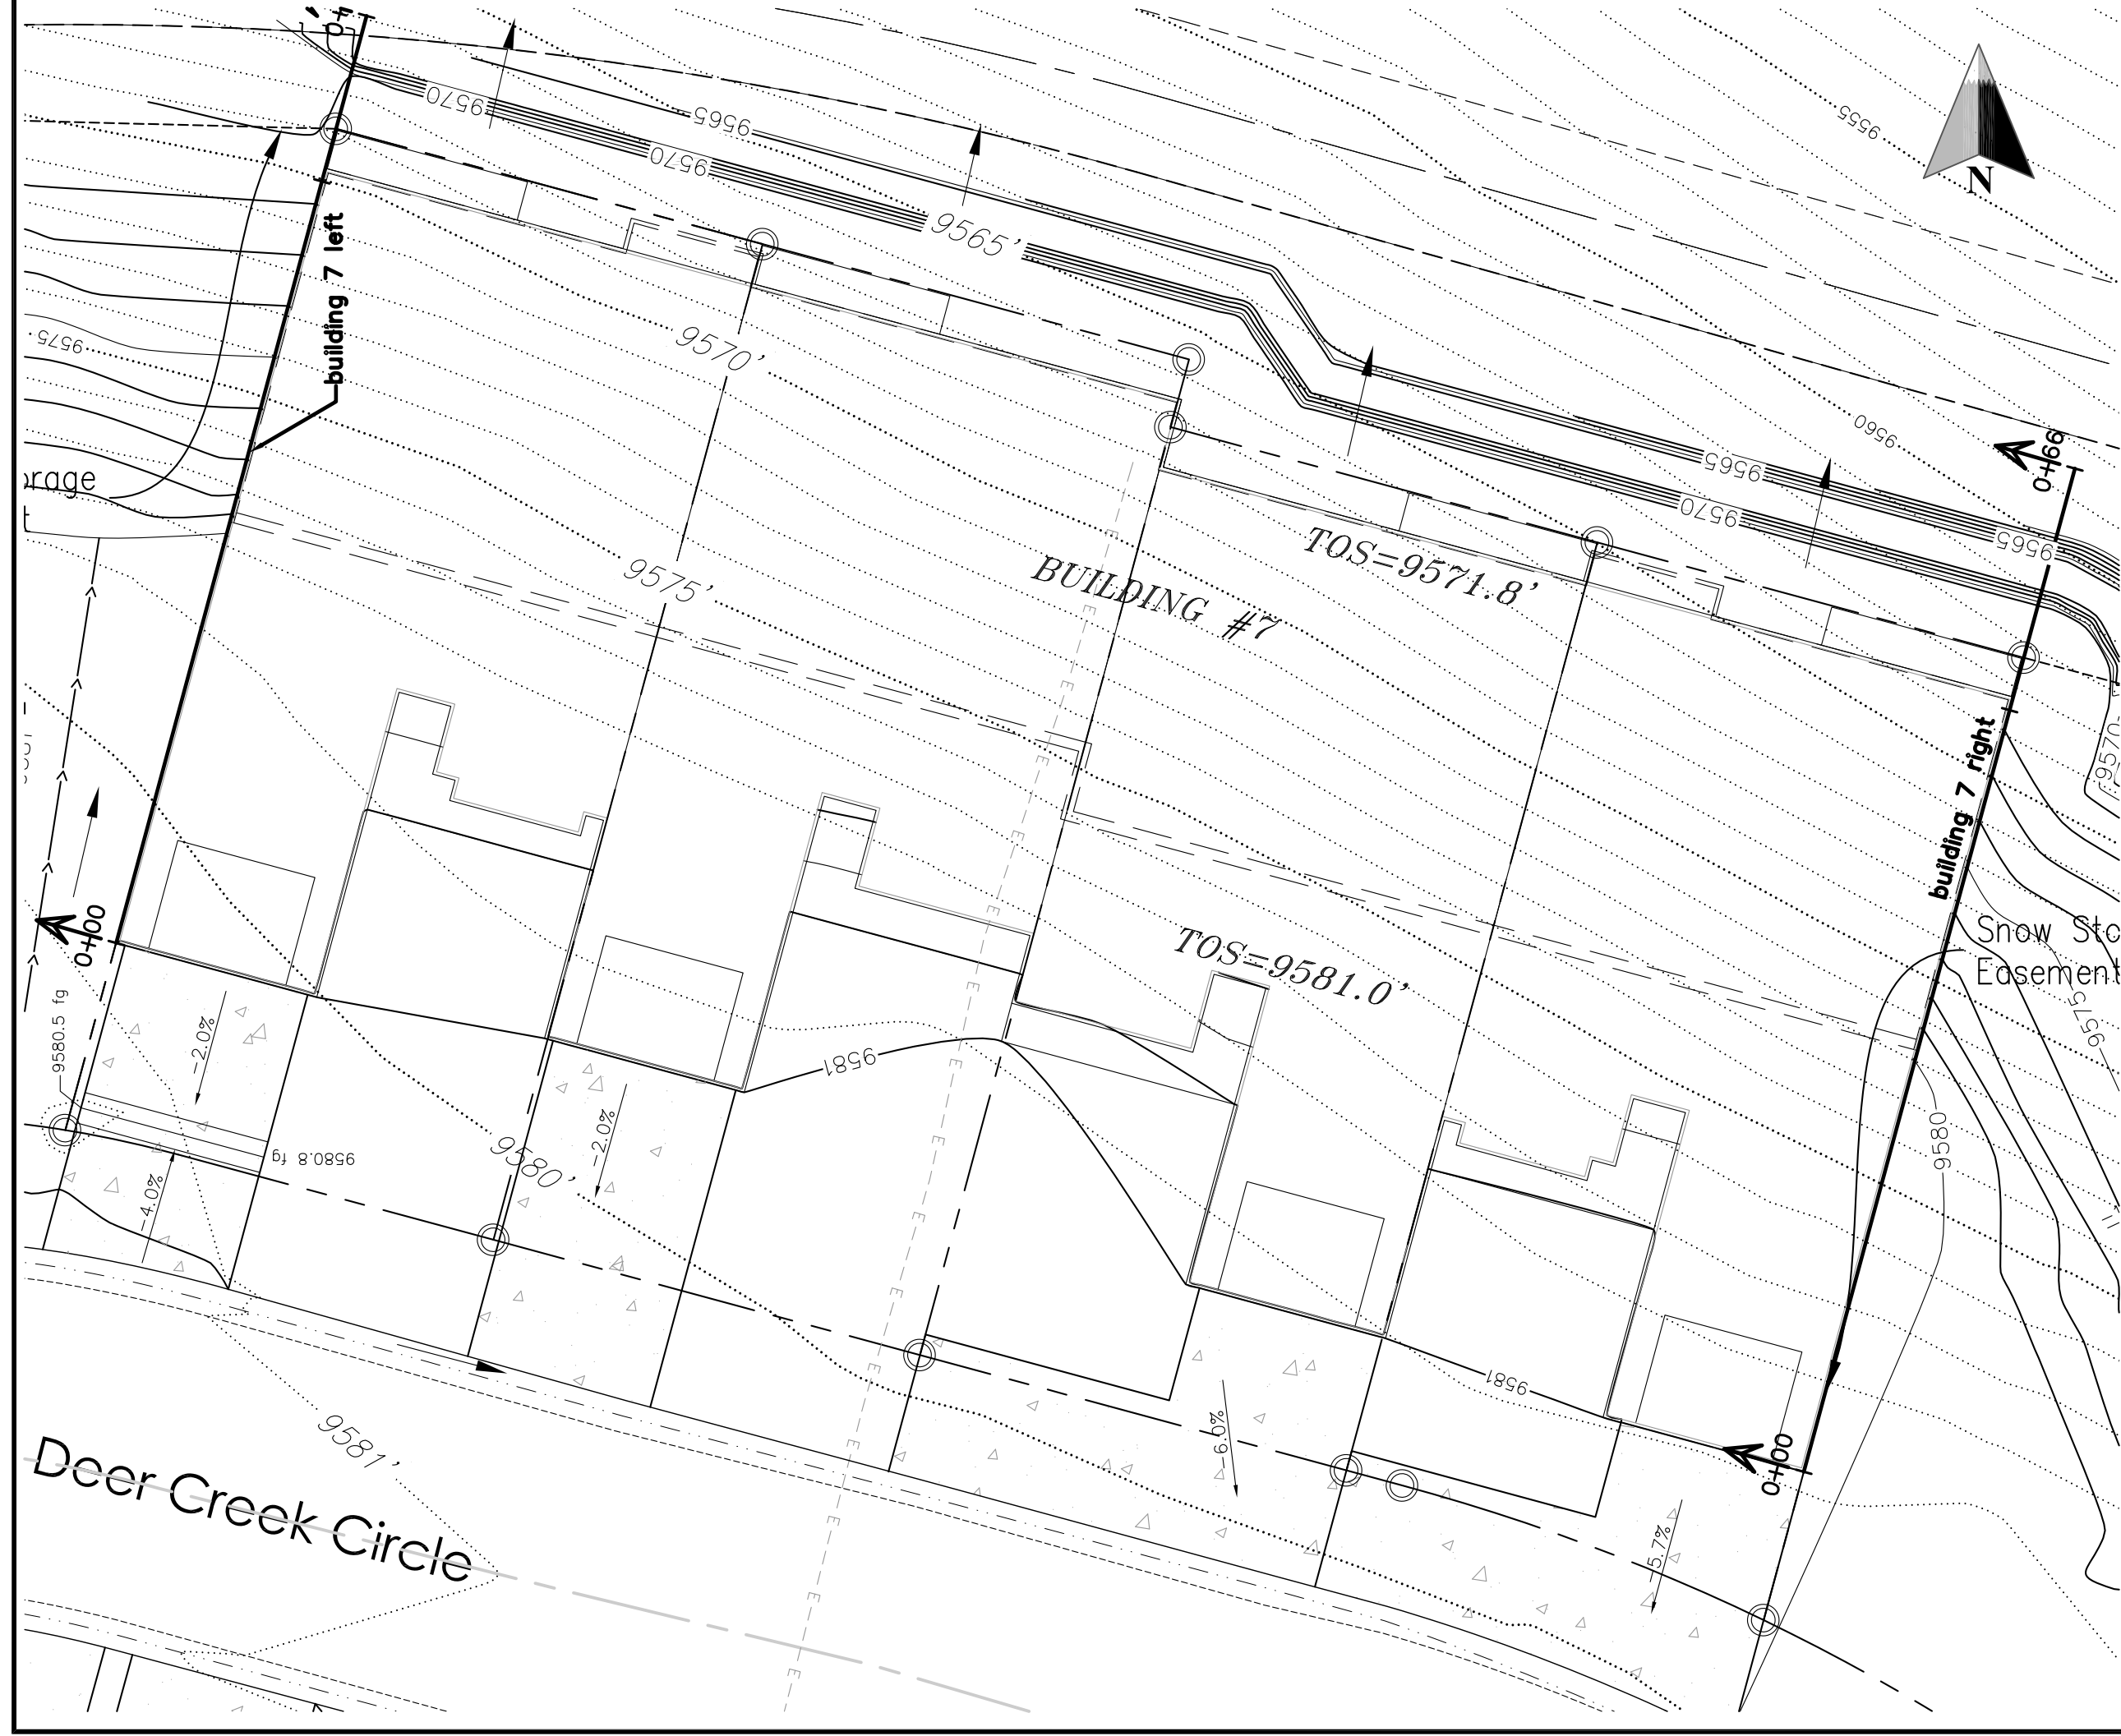


building 7 right PROFILE

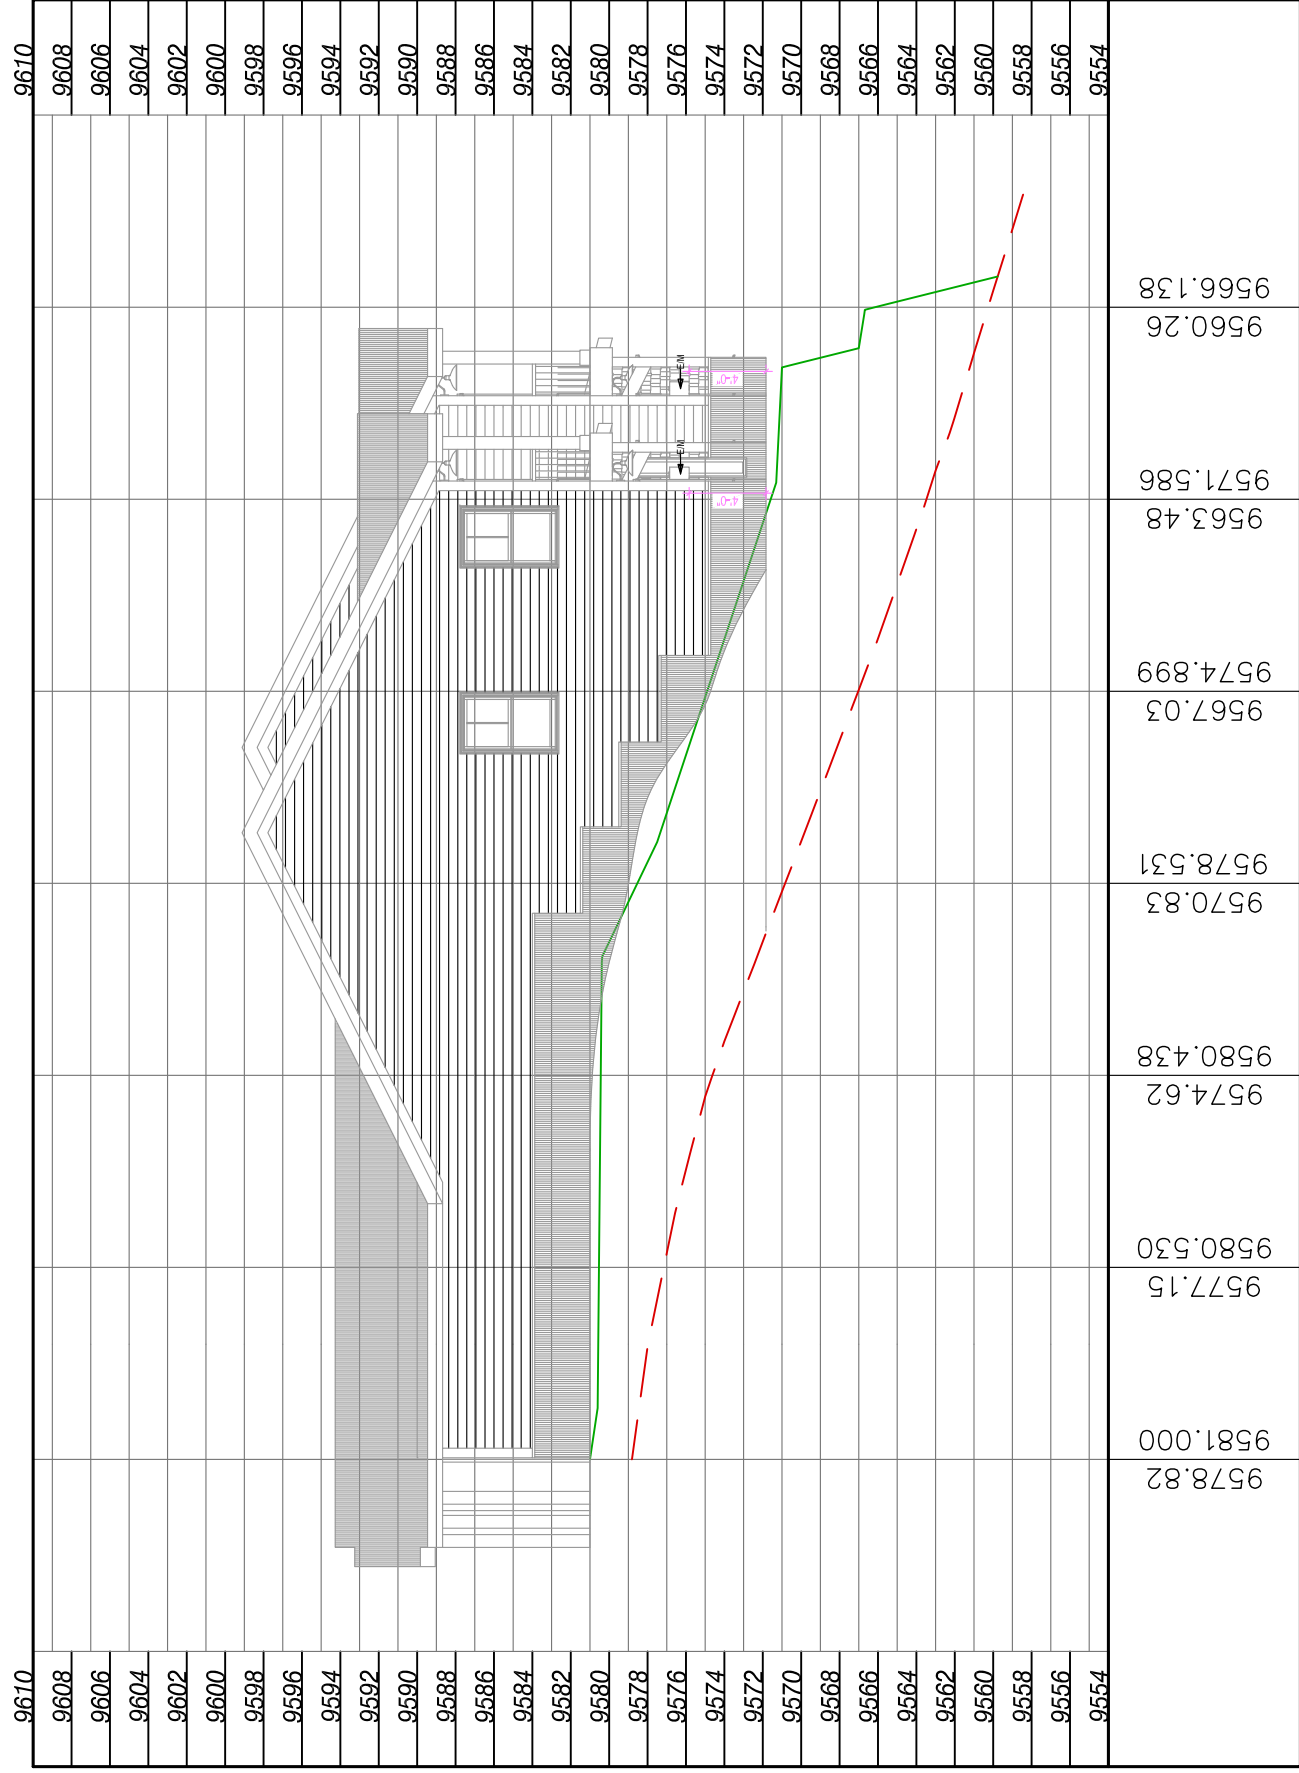


building 7 left PROFILE

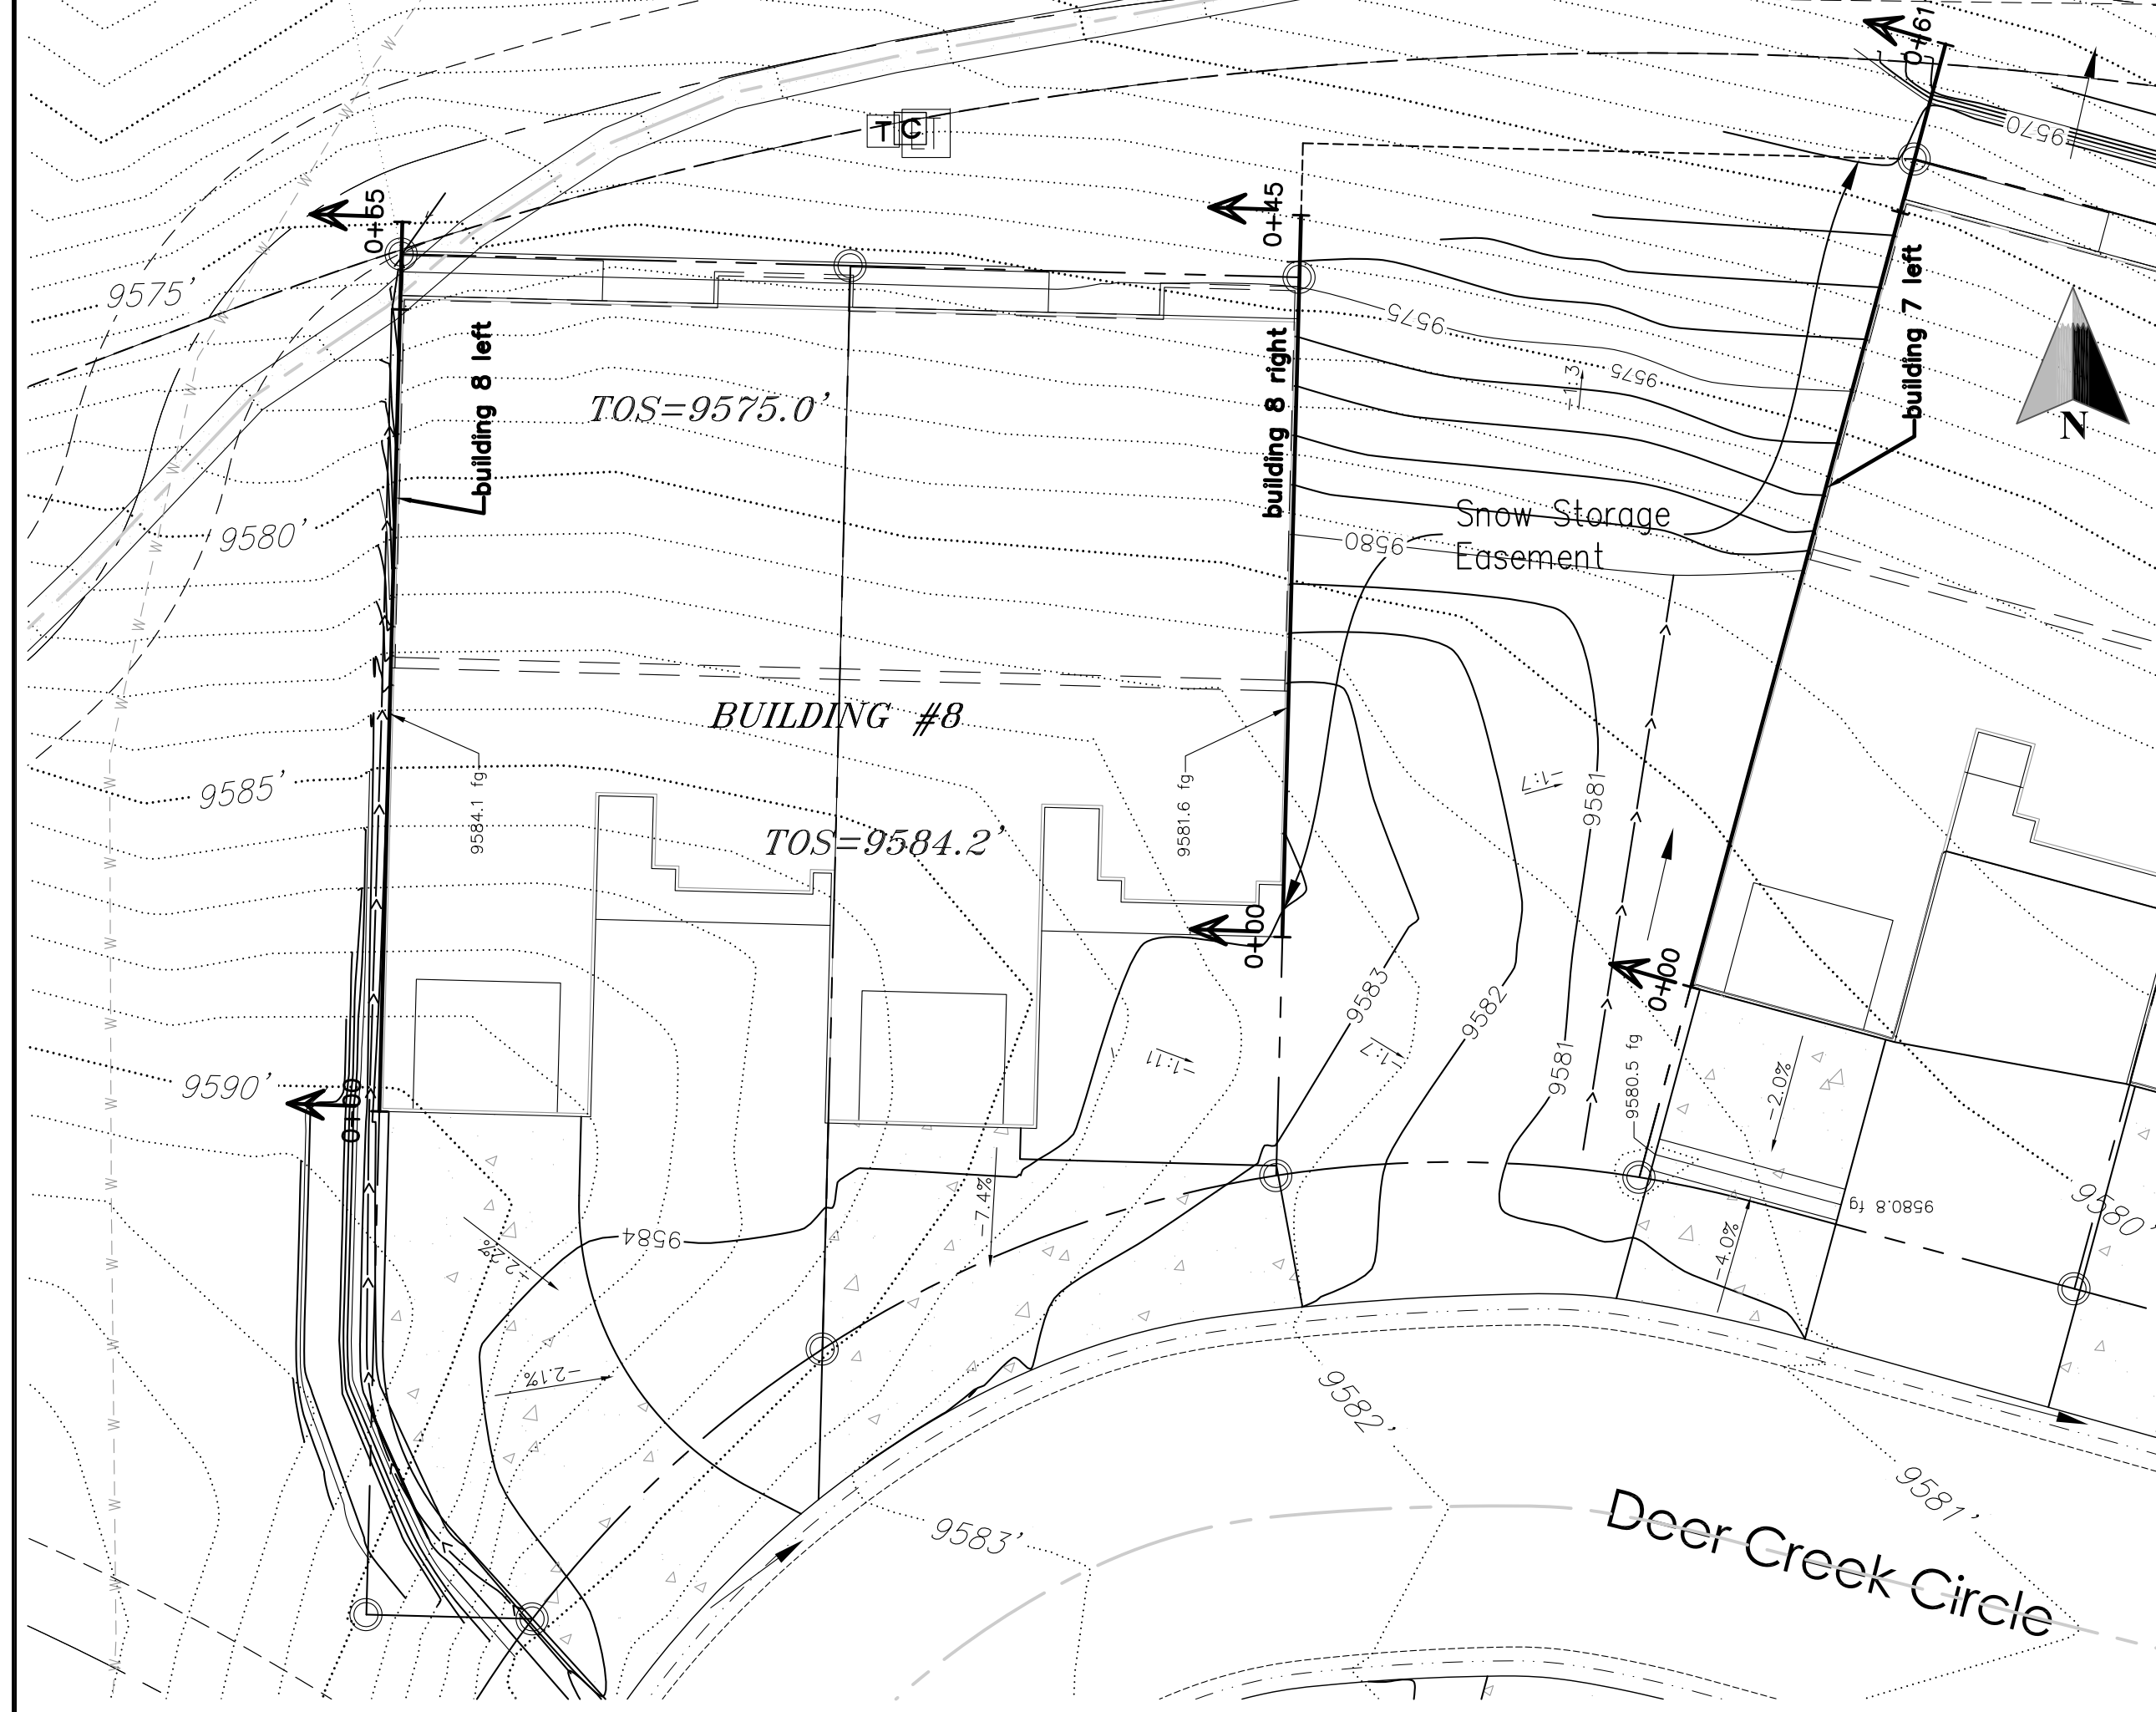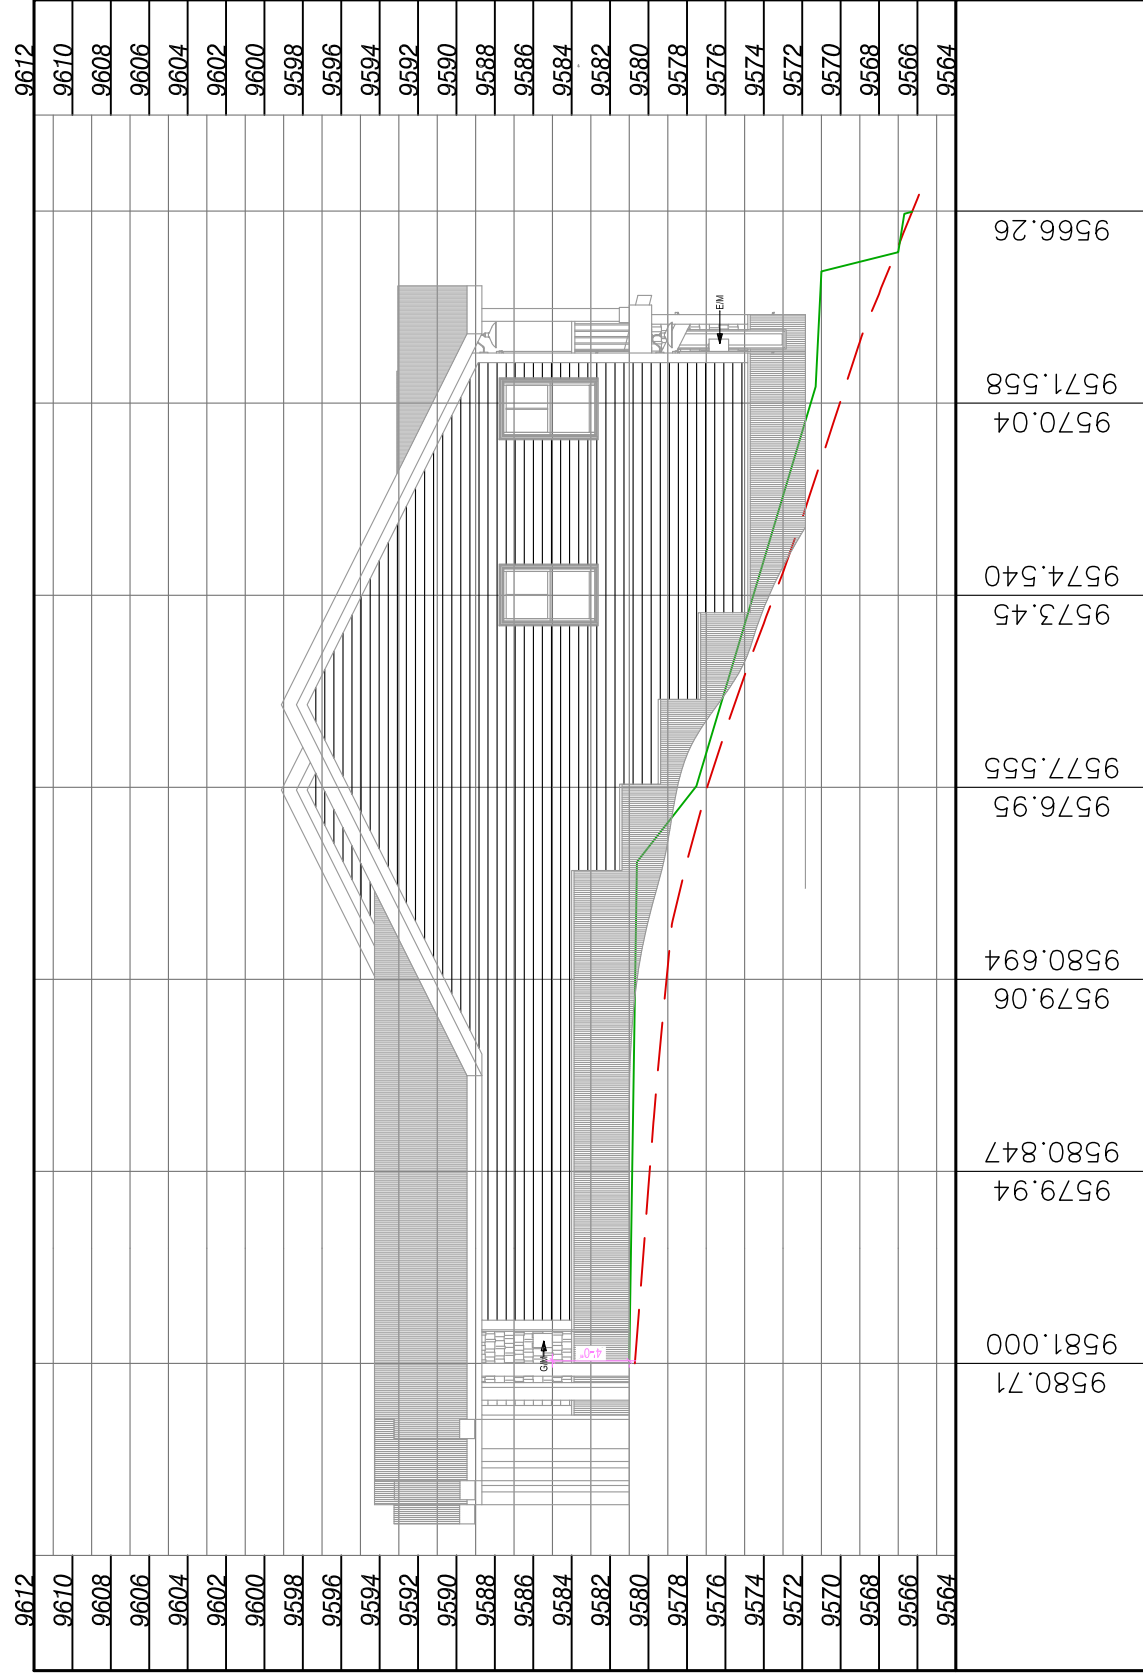

building 8 left PROFILE

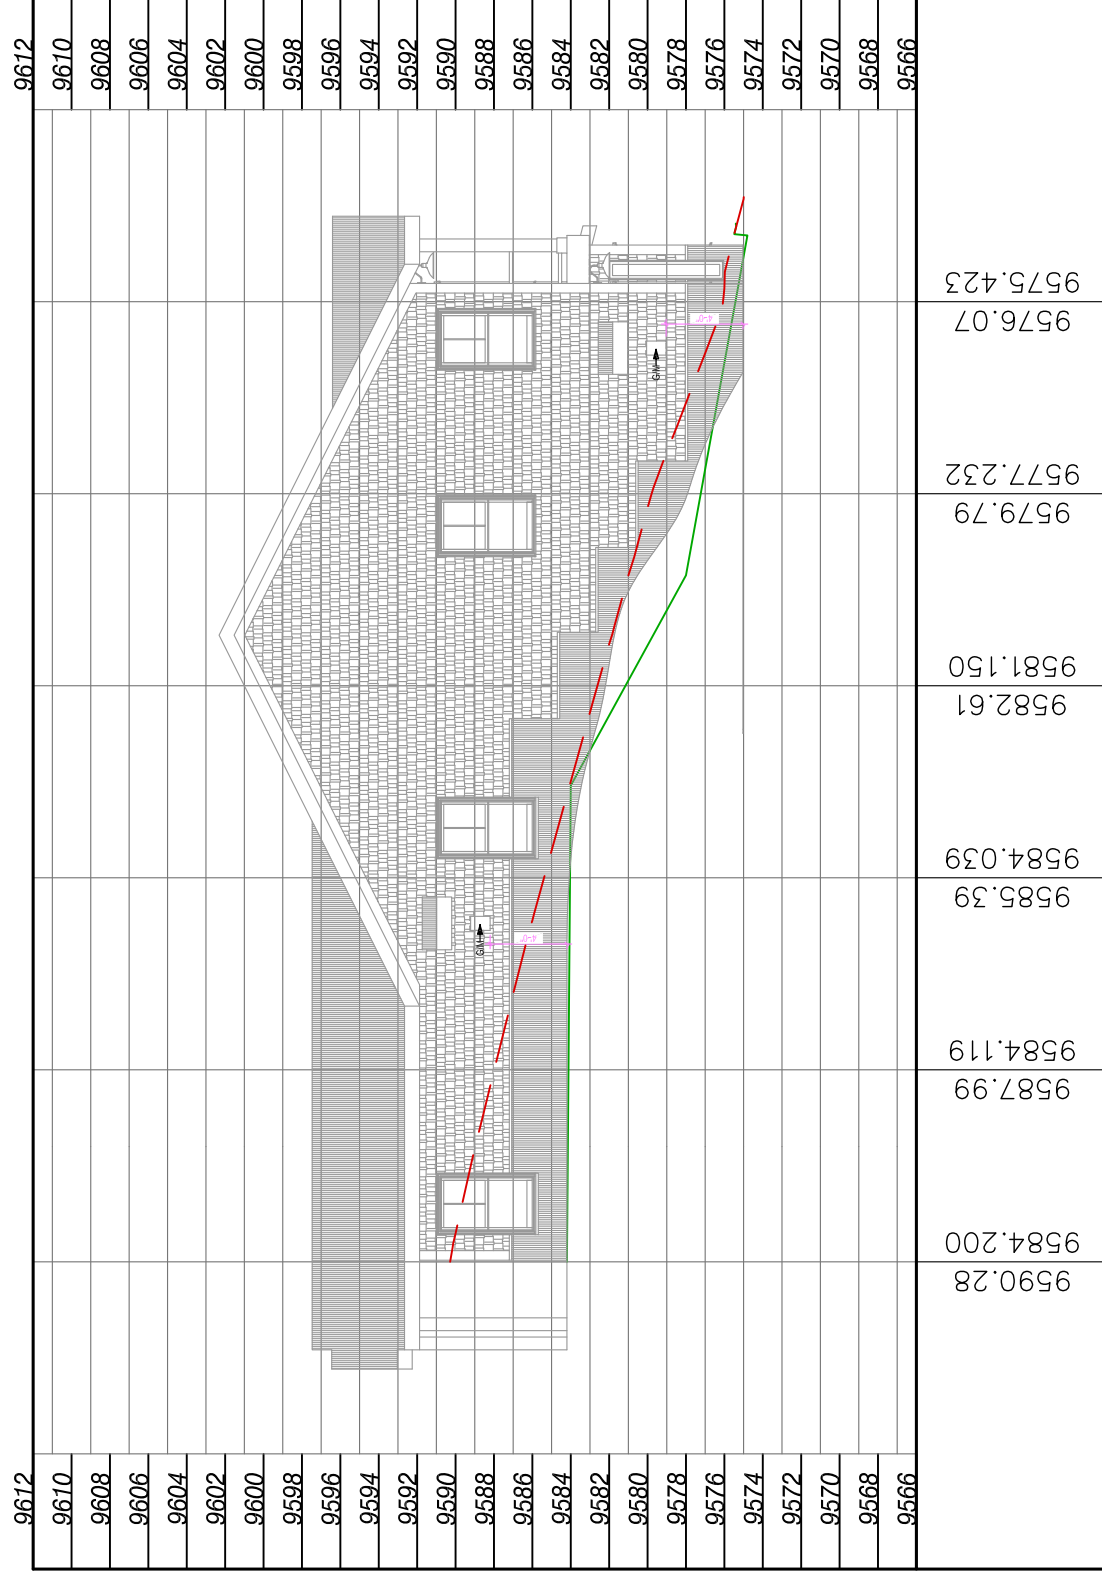

building 8 right PROFILE

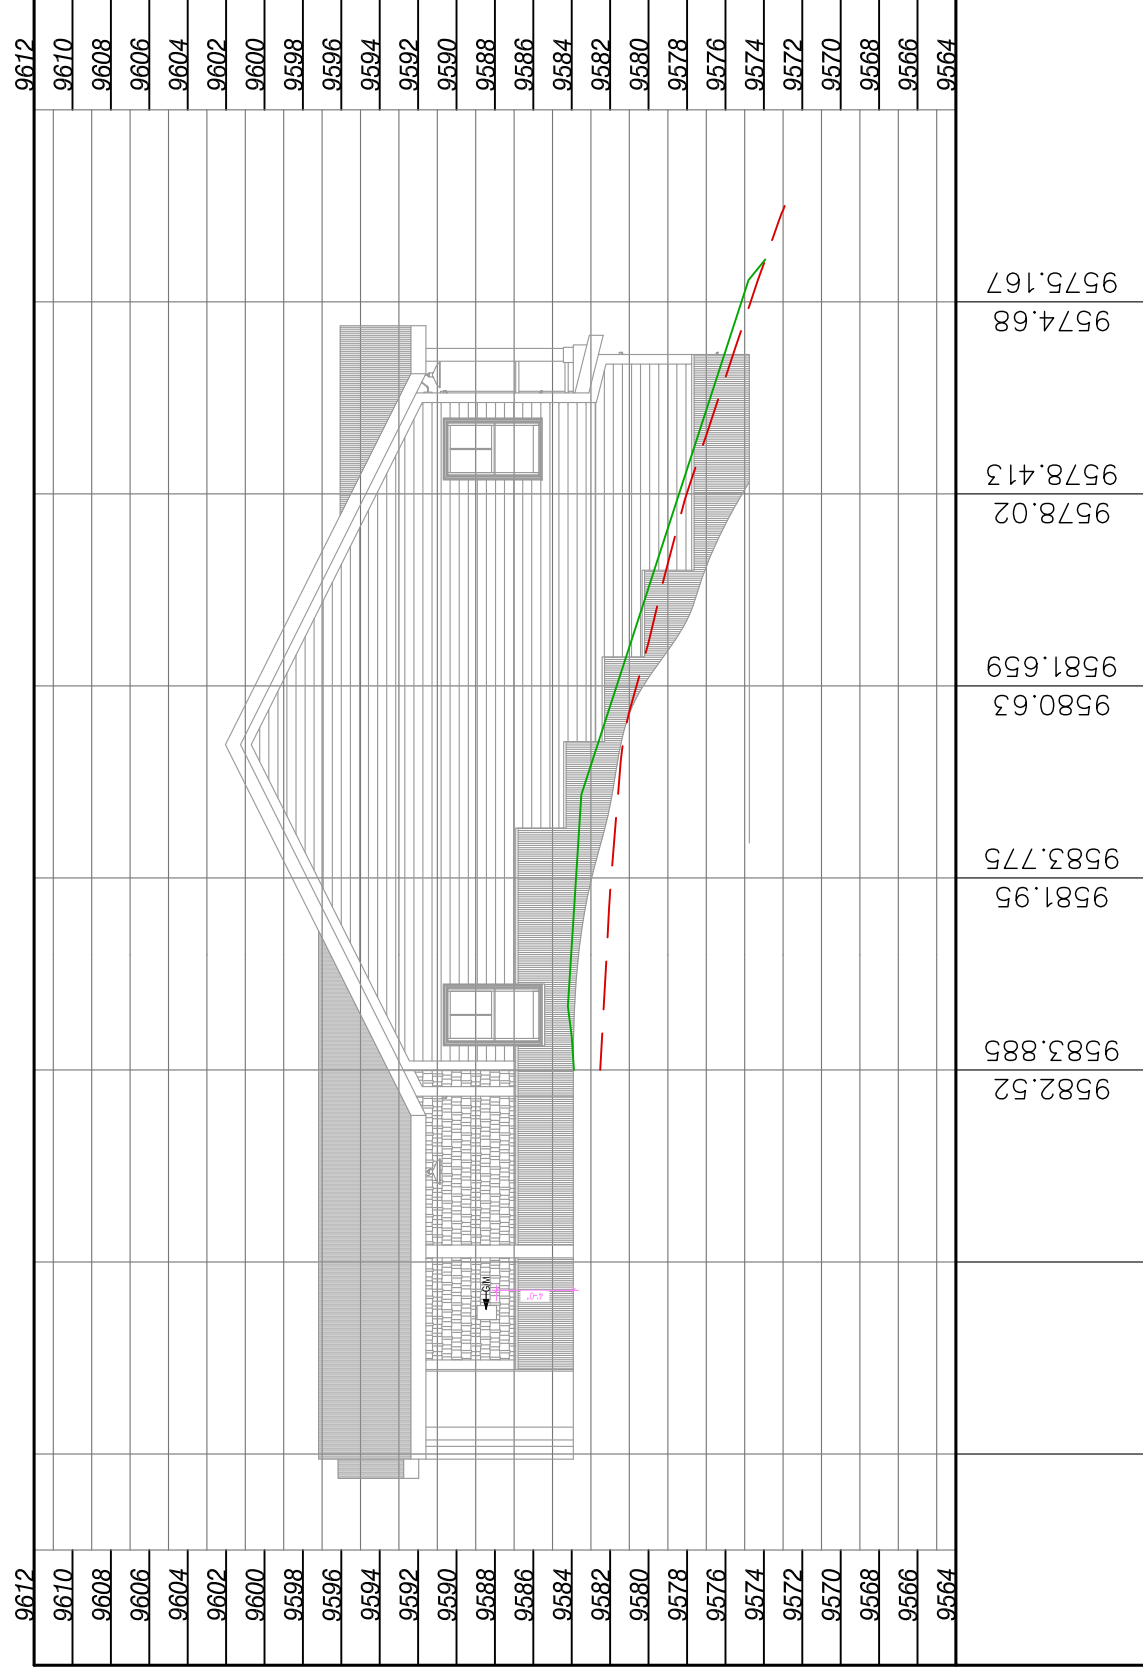

ENGINEER'S STAMP

G4

SHEET:

THE PROSPECT HOMESTEAD SUBDIVISION  
LOTS 7 - 22  
DEER CREEK CIRCLE  
CRESTED BUTTE, COLORADO 81224  
GUNNISON COUNTY, COLORADO 81230

DRAWN BY: JLB  
CHECKED BY: RWW  
SCALE: AS NOTED  
MOST CURRENT DATE: 2/23/2020  
JOB NO. 3044

GRADING PLAN  
BUILDING 7 & 8

WILLIAMS ENGINEERING LLC  
400 NORTH MAIN STREET  
GUNNISON, CO 81230  
EMAIL: wengr@att.net



Know what's below.  
Call before you dig.

DESIGNED FOR DESIGN REVIEW

2/23/20